




2

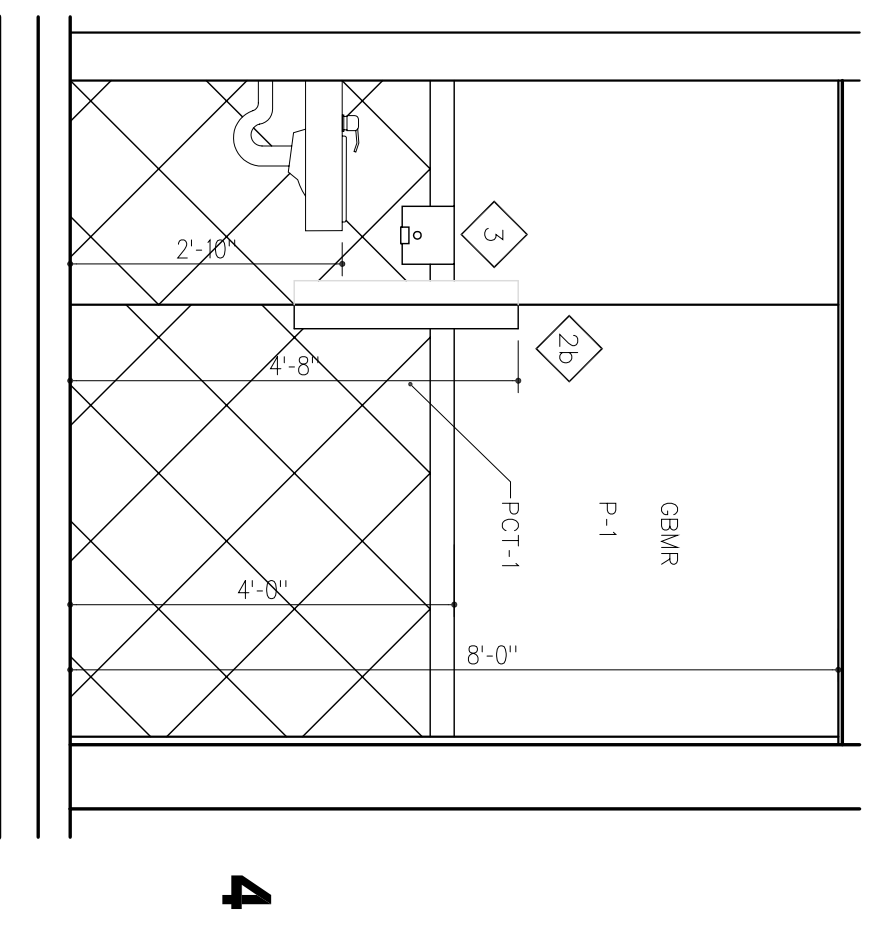


4

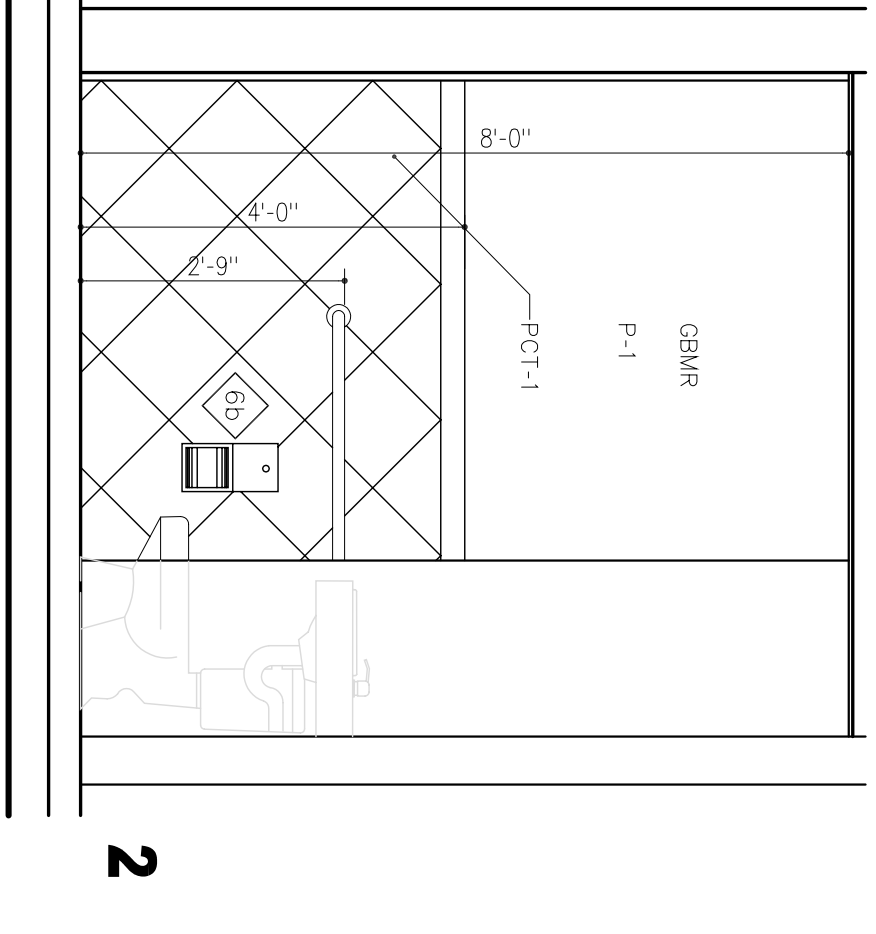


2

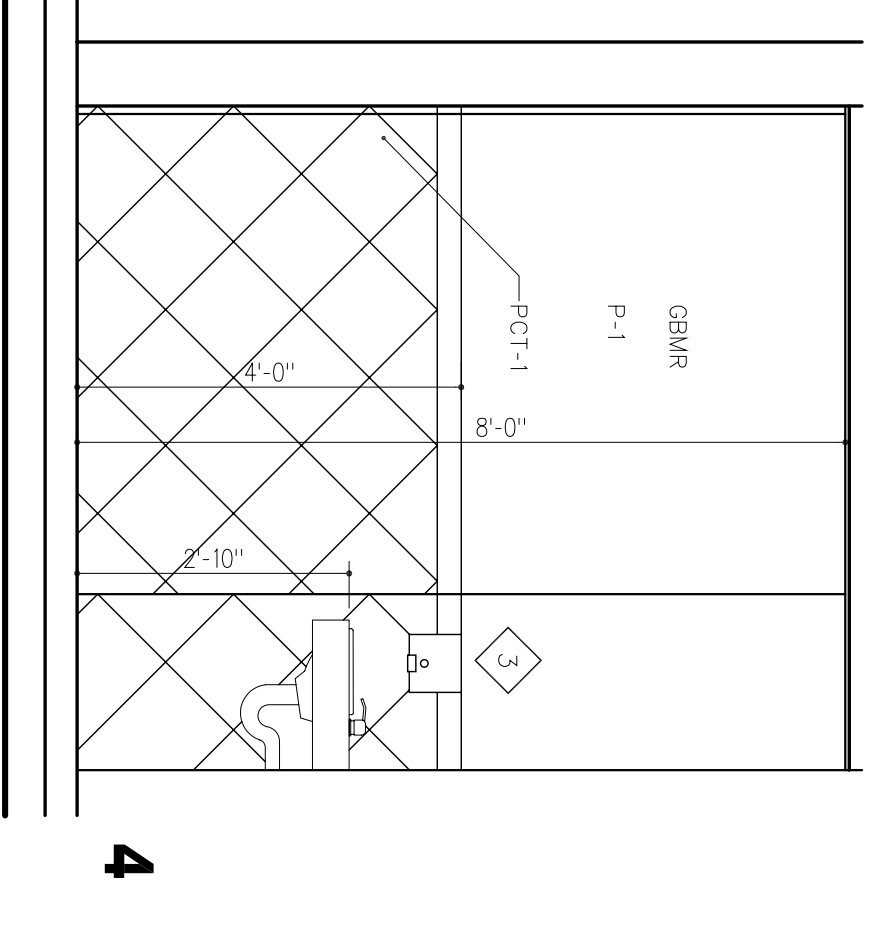


4

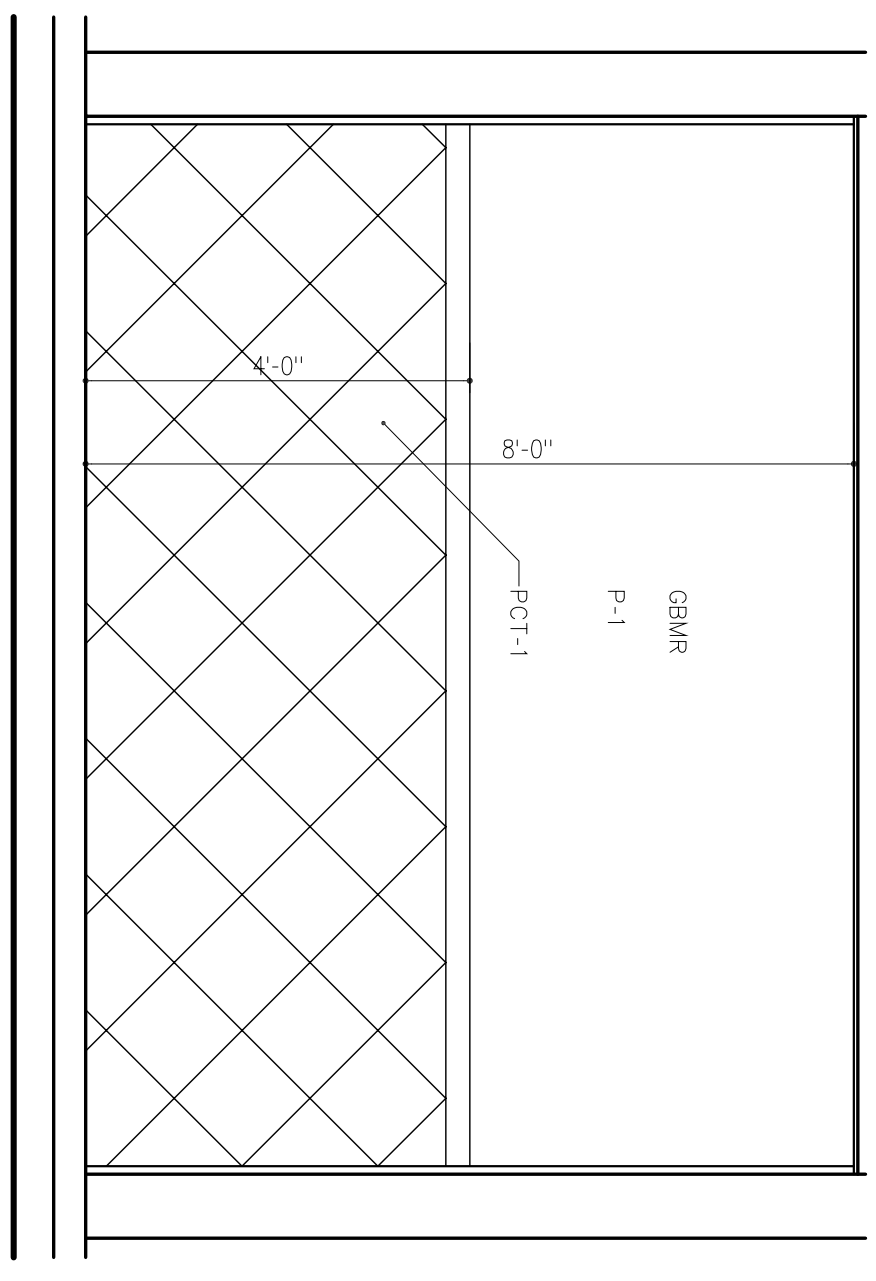


1

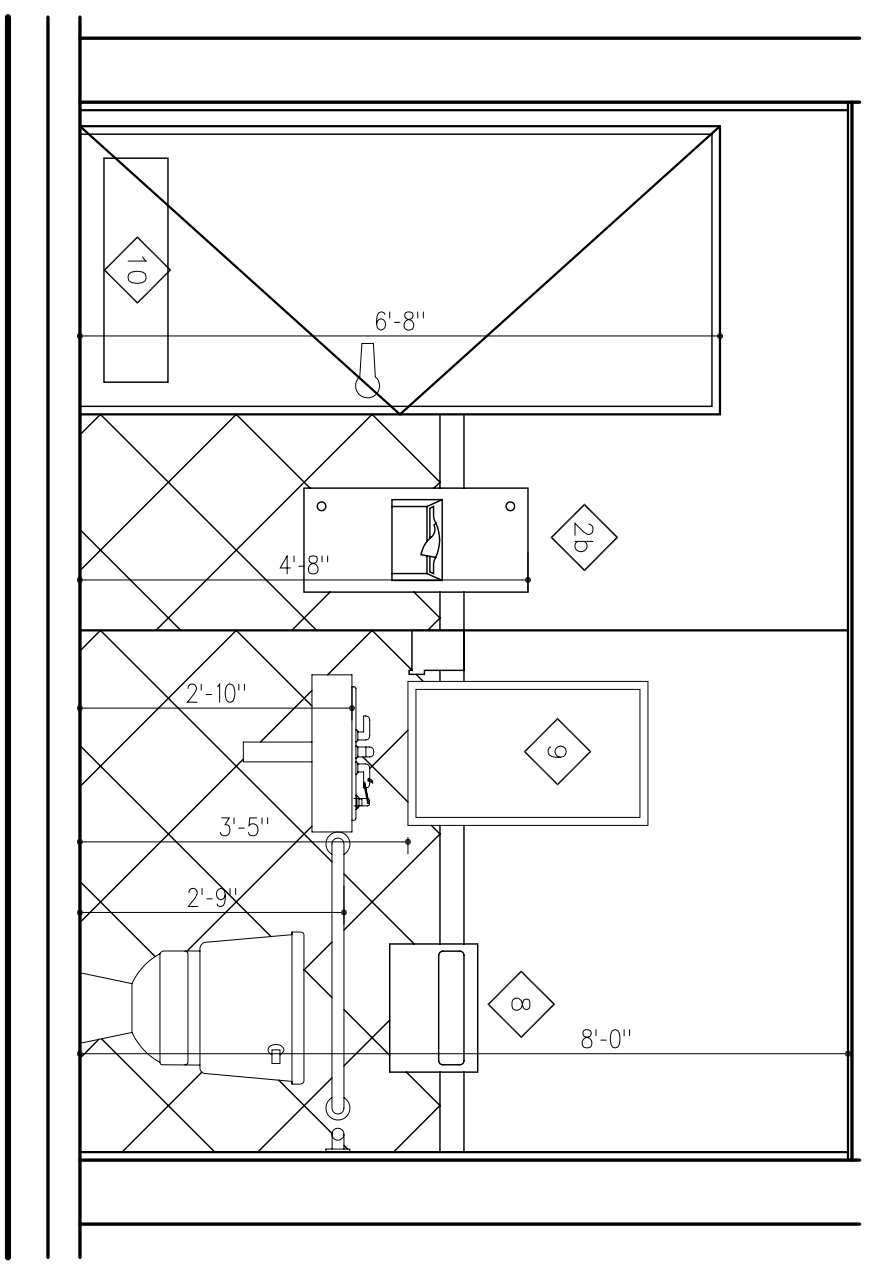

3

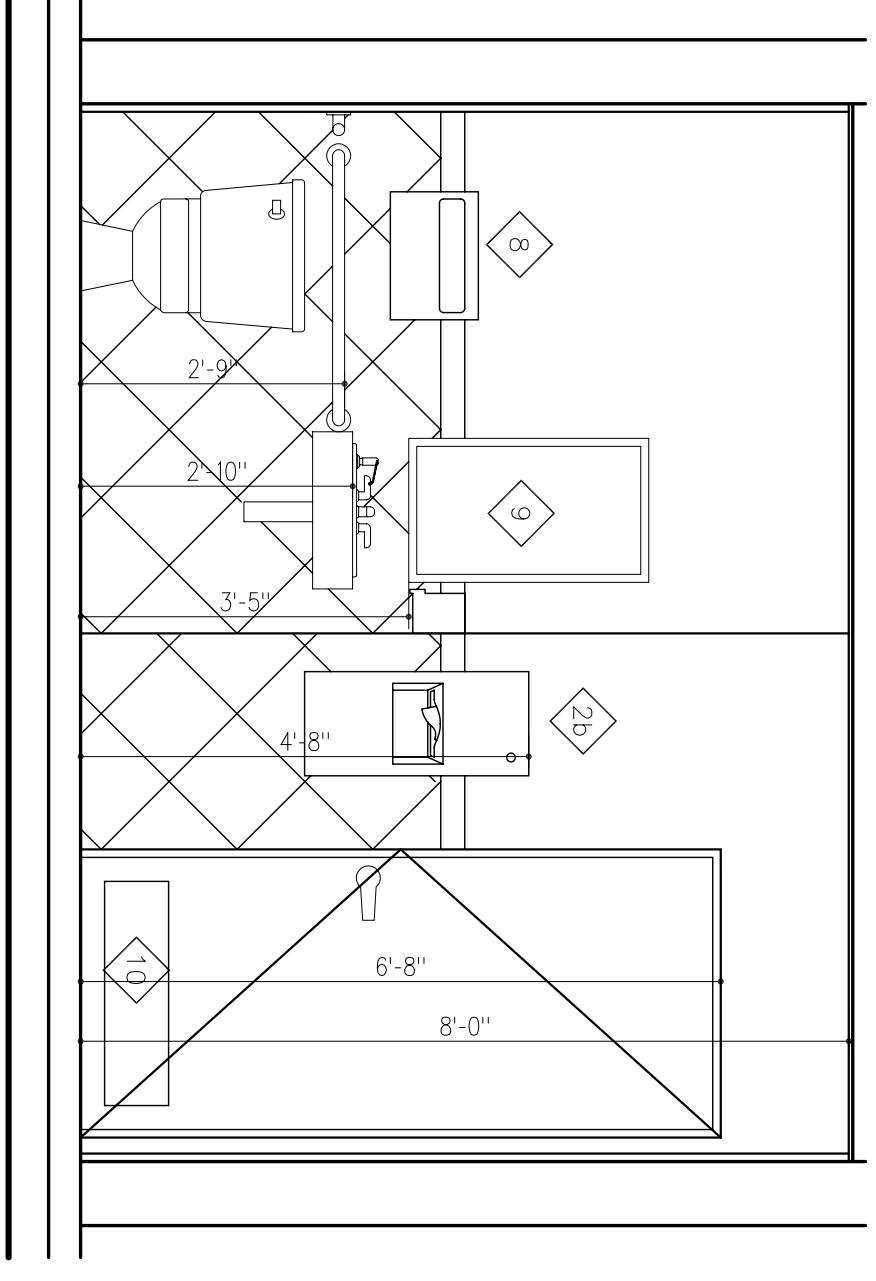

1

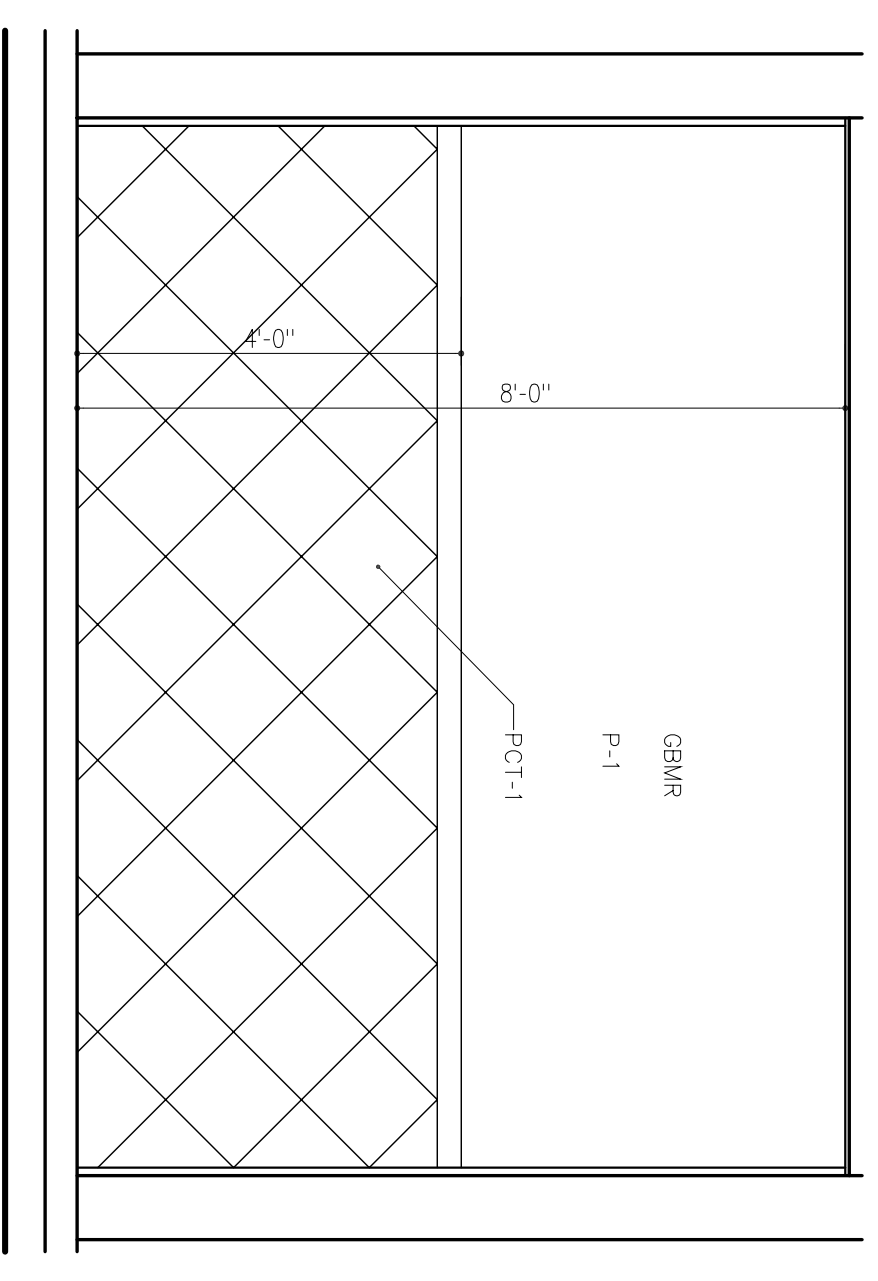


3

**WOMEN RESTROOM ELEVATION BLD. 1**

SCALE: 1/2" = 1'-0"

**MEN RESTROOM ELEVATION BLD. 1**


SCALE: 1/2" = 1'-0"

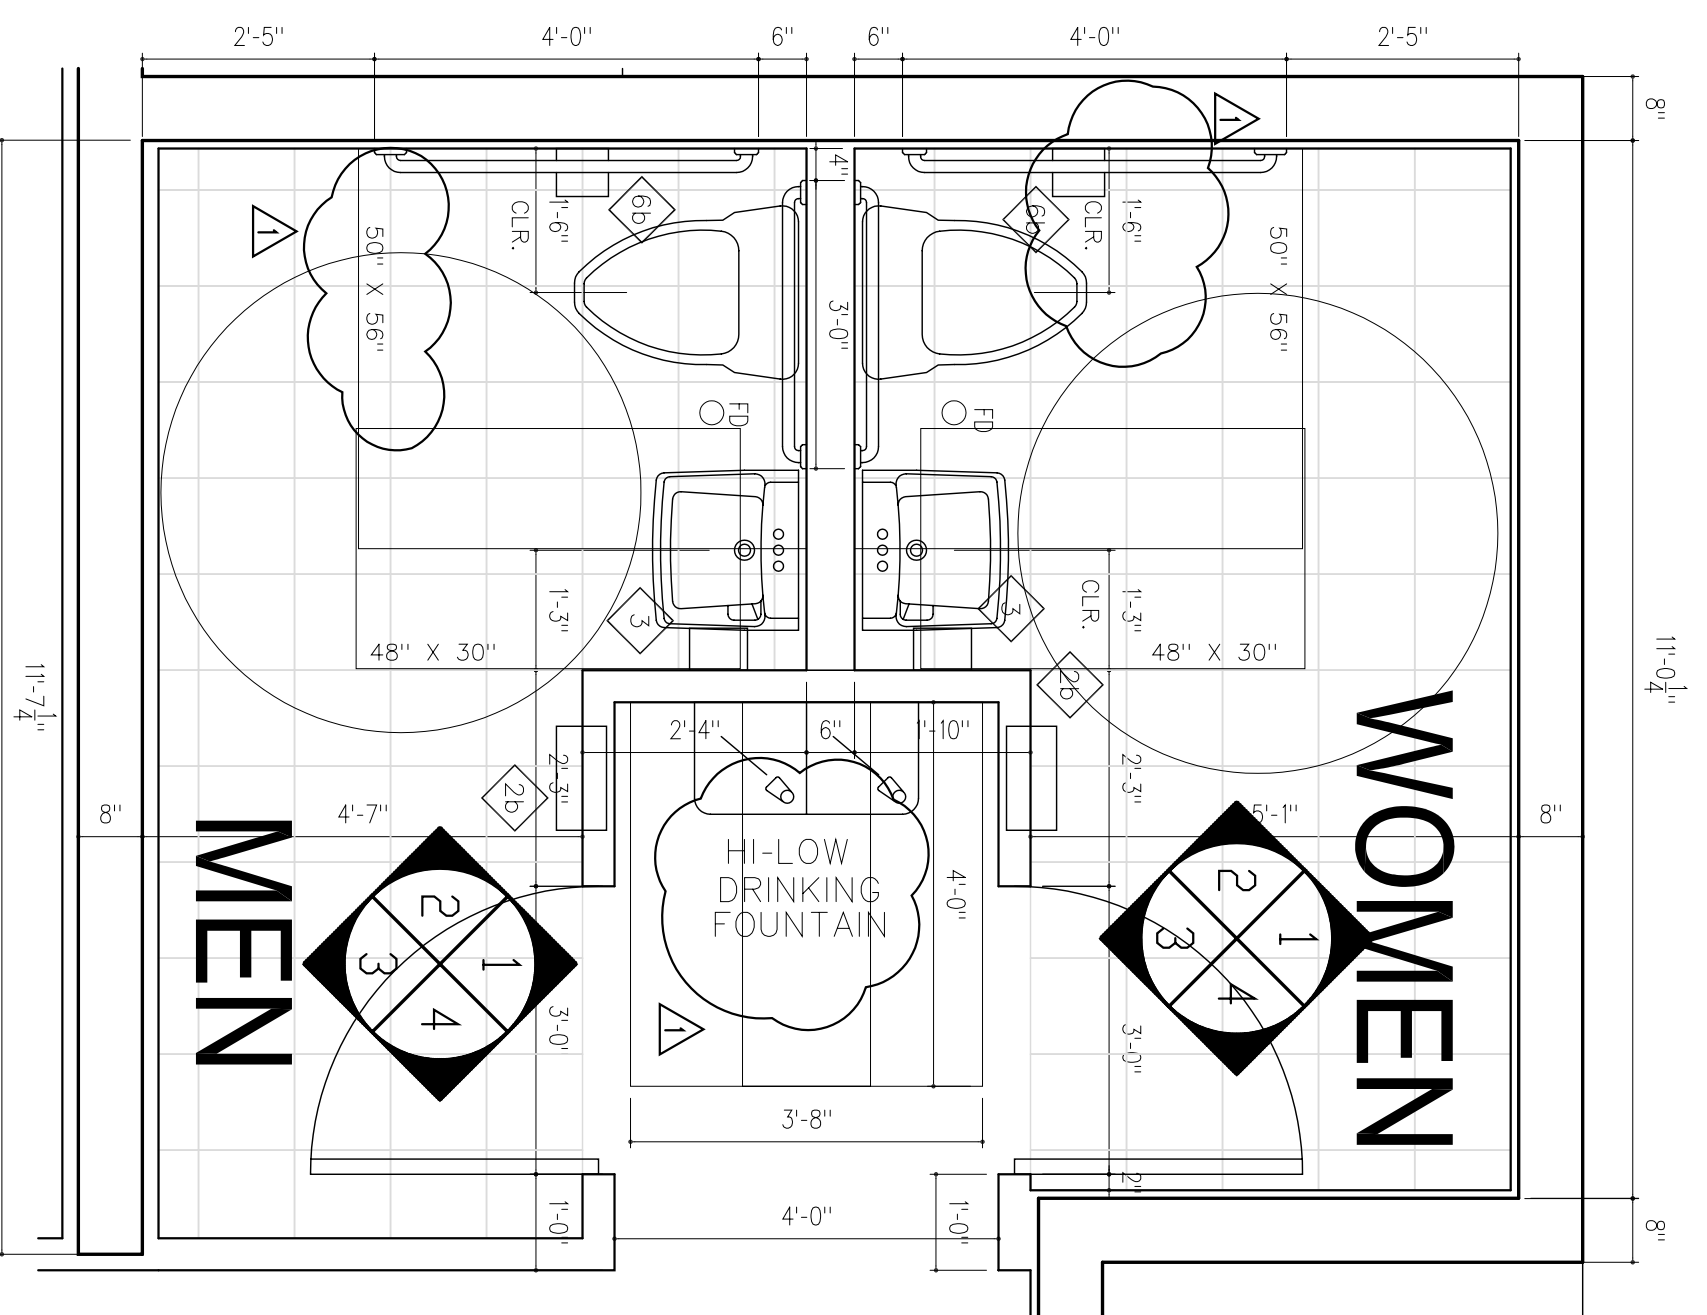


\*\* THE CENTER OF SINK SHALL BE A MINIMUM OF 18" FROM THE CENTER OF TOILET STALL AS REQUIRED BY SEPARATE PARTS OF THE CODE. FLOOR MOUNTED WATER CLOSURE MAY BE USED. DETAILS REFER TO 0411/15, 17, 8, 18

- NOTES:
1. ACCESSIBLE WATER CLOSET DEPTH IS 30 INCHES AND IT IS FLOOR MOUNTED.
  2. ACCESSIBILITY TO TOILET STALL DOOR IS IN COMPLIANCE WITH FABRC AND ADA GUIDELINES TO BE APPROVED.
  3. IF PROVIDED, MIRRORS SHALL BE MOUNTED WITH THE BOTTOM EDGE OF THE REFLECTED SURFACE NO HIGHER THAN 40 INCHES ABOVE THE FINISH FLOOR.
  4. ABOVE THE FINISH FLOOR, MIRRORS SHALL BE INSULATED. THERE SHALL BE NO SHARP OR ABRASIVE SURFACE UNDER LAVATORIES.
  5. ACCESSIBLE TOILET STALL (COMPARTMENT) CAN BE 36" IN DEPTH IF YOU HAVE A STANDARD ACCESSIBLE TOILET STALL IS INCREASED AT 3 INCHES. THEN A FLOOR MOUNTED WATER CLOSET MAY BE USED. FLOOR MOUNTED STANDARD ACCESSIBLE TOILET STALL IS INCREASED AT 3 INCHES.
  6. THE CERAMIC TILES IN THE TOILET ROOM FLOORS SHALL BE 12" X 12" (305MM X 305MM).
  7. SECTION BETWEEN THE FLOOR AND WALL SHALL BE COVERED TILES OF FIN FLOOR WITH A MINIMUM OF 1/2" CLEARANCE FROM THE FIN FLOOR DIMENSIONS TO LOCATE PLUMBING FIXTURES ARE TO FINISHED SURFACE OF WALL.
  - 8.

- LEGEND
- 10 7 GAL. PAPER TOWEL DISPENSER AND WASTE RECEPTACLE ( SURFACE MOUNTED 64676-9)
  - 10 7 GAL. PAPER TOWEL DISPENSER AND WASTE RECEPTACLE ( 4" RECESSED 64676-2)
  - 20 1.8 GAL. PAPER TOWEL DISPENSER AND WASTE RECEPTACLE ( SURFACE MOUNTED 64622-9)
  - 20 1.8 GAL. PAPER TOWEL DISPENSER AND WASTE RECEPTACLE ( 4" RECESSED 64622)
  - 3 1.8 GAL. PAPER TOWEL DISPENSER
  - 4 BABY CHANGING STATION (SURFACE MOUNTED 9012)
  - 5 SANITARY NAPKIN/PAPERON VENDOR (4" RECESSED 0488)
  - 60 DUAL ACCESS PARTITION MOUNTED DUAL TOILET PAPER DISPENSER (0032)
  - 6b SURFACE MOUNTED DUAL ROLL TOILET PAPER DISPENSER (0030)
  - 7 HEAVY DUTY UTILITY HOOK (1530)
  - 8 SURFACE MOUNTED TOILET SEAT COVER DISPENSER (047750)
  - 9 MIRROR
  - 10 KICK PLATE
- ALL TOILET ACCESSORIES BY AMERICAN SPECIALTIES INC. OR APPROVED EQUAL.

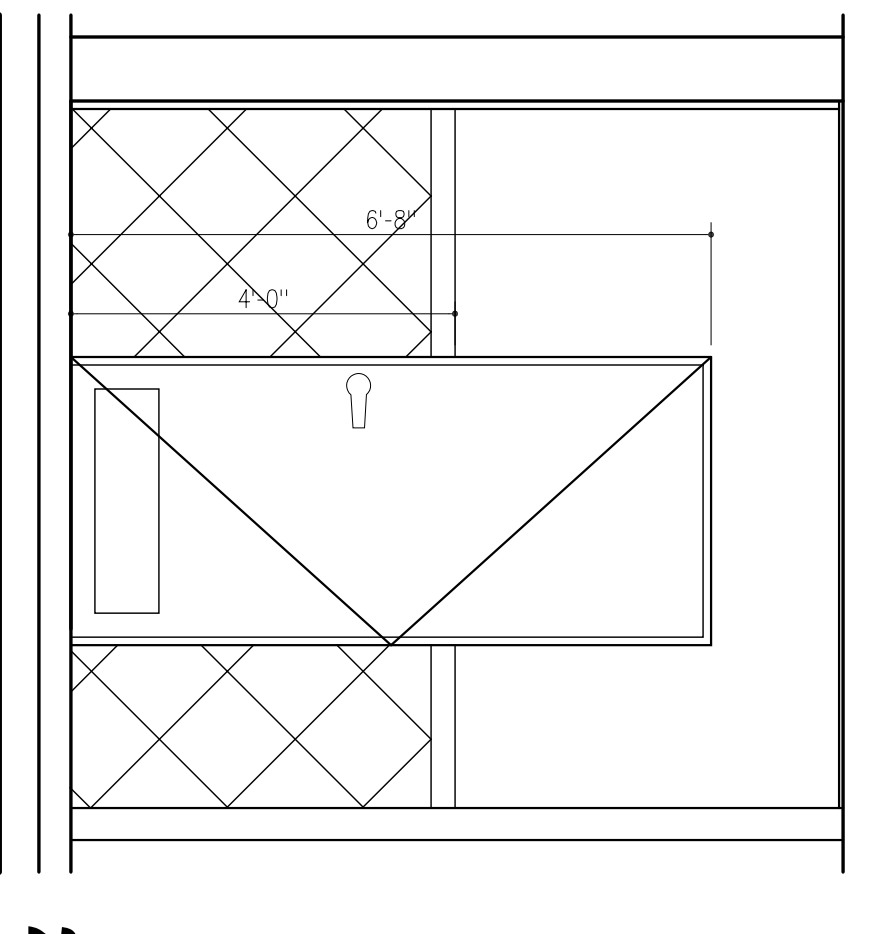


2

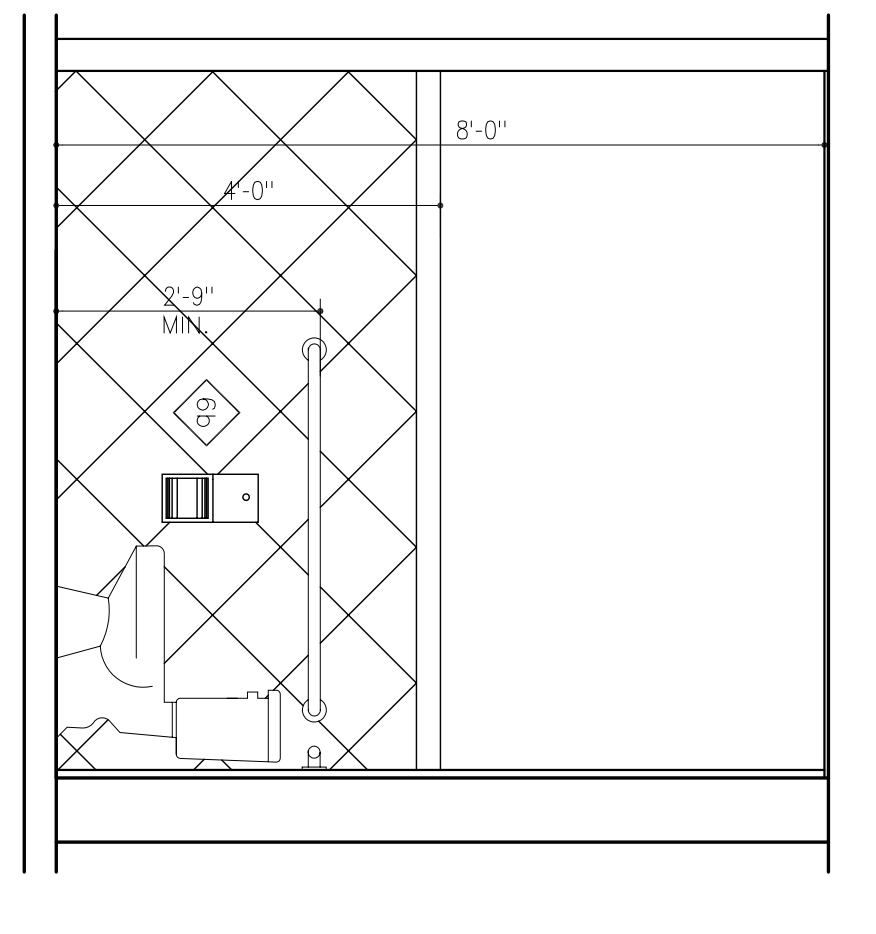


4

**PASTORS TOILET ELEVATION BLD. 1**

SCALE: 1/2" = 1'-0"

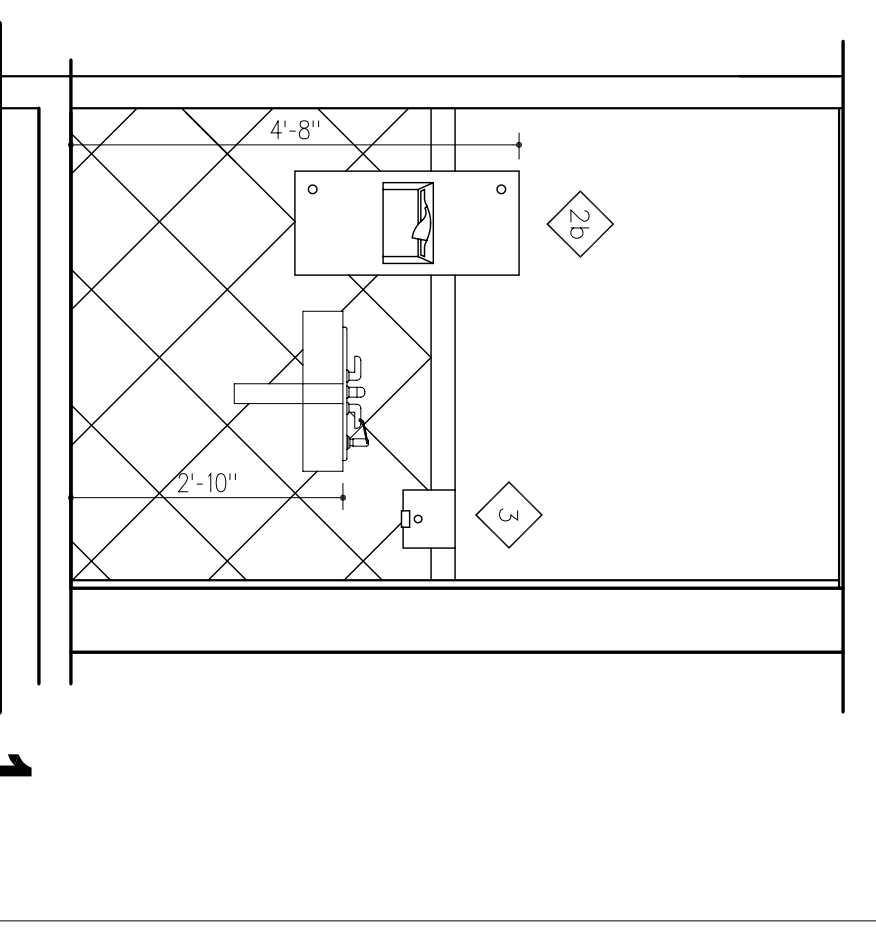

1

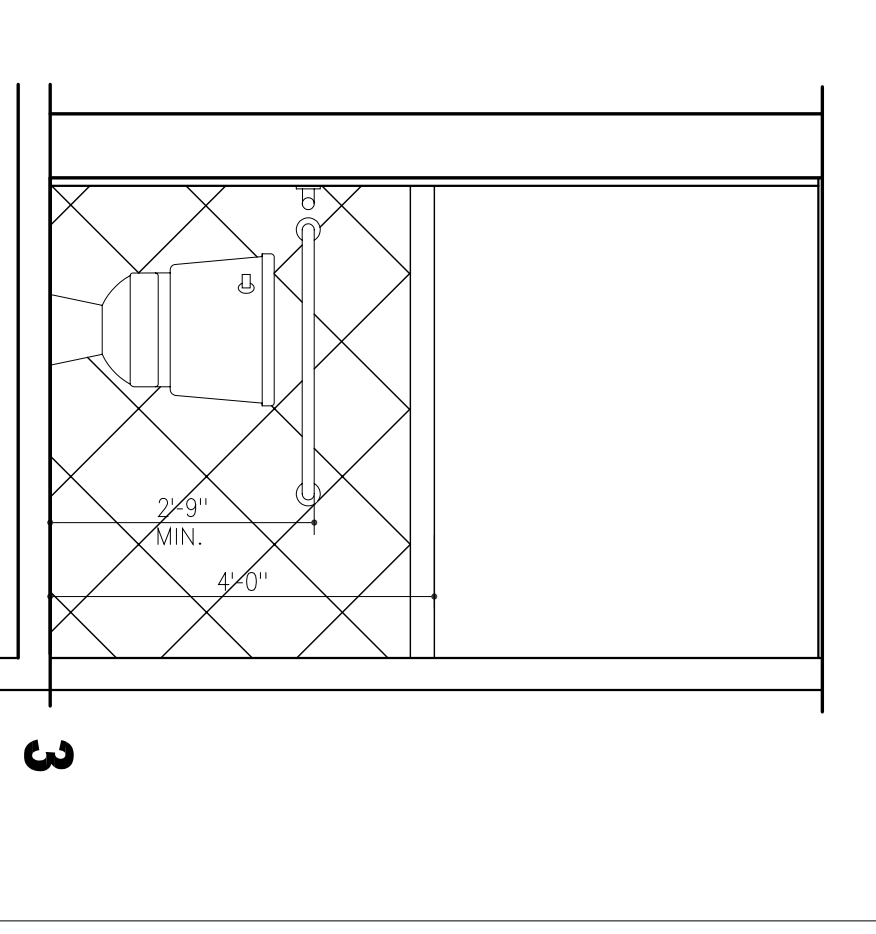


3

**MEN & WOMEN RESTROOM BLD. 1**

SCALE: 1/2" = 1'-0"

**PASTORS OFFICE TOILET BLD. 1**

SCALE: 1/2" = 1'-0"

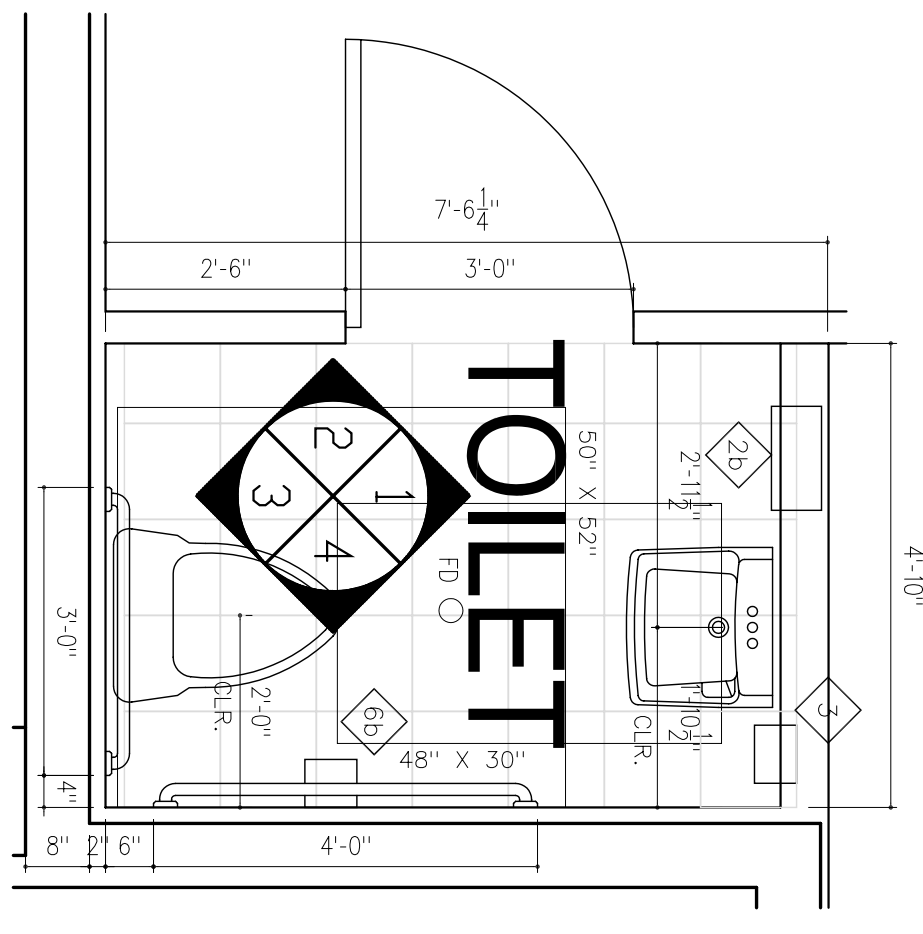

**FIRST HAITIAN FREE CHURCH OF NAZARENE**

First Haitian Free Church of Nazarene by Faith  
ORLANDO, FLORIDA

**RAMOSMARTINEZ ARCHITECTS, INC.**  
AA 26000528  
MIAMI: 305-548-3008, 305-548-3220  
NEW YORK: 212-696-1111, 212-696-1112

**A-9.4**

**ENGARGED PLANS**  
REVISIONS:  
DATE: 08-10-07  
DRAWN BY:  
CHECKED BY:

**RESTROOM FLOOR PLANS**  
308 SOUTH ORANGE BLOSSOM TRAIL  
ORLANDO, FLORIDA