

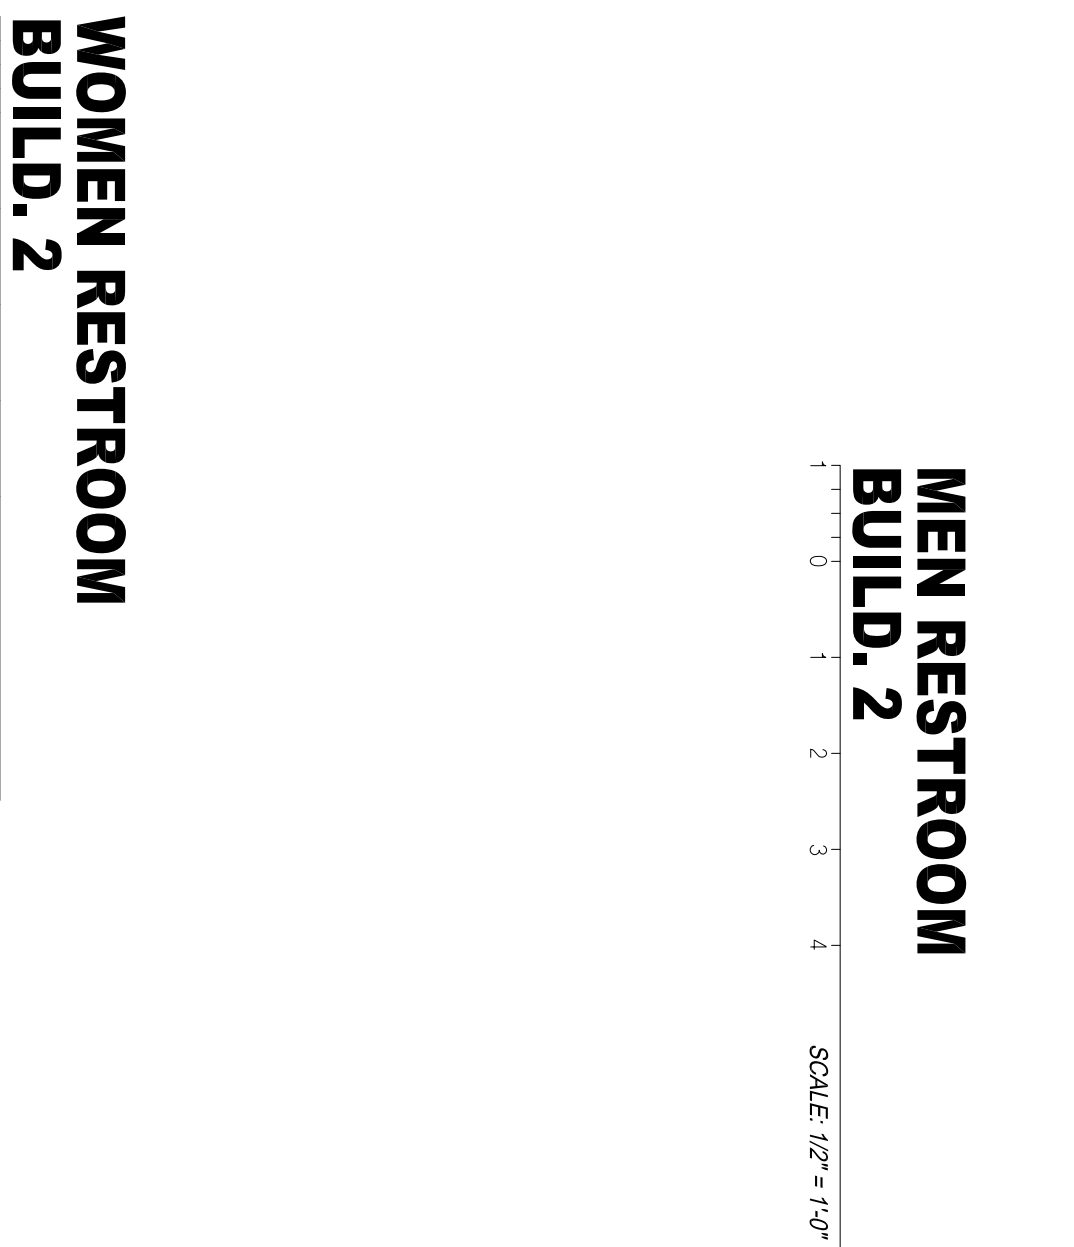
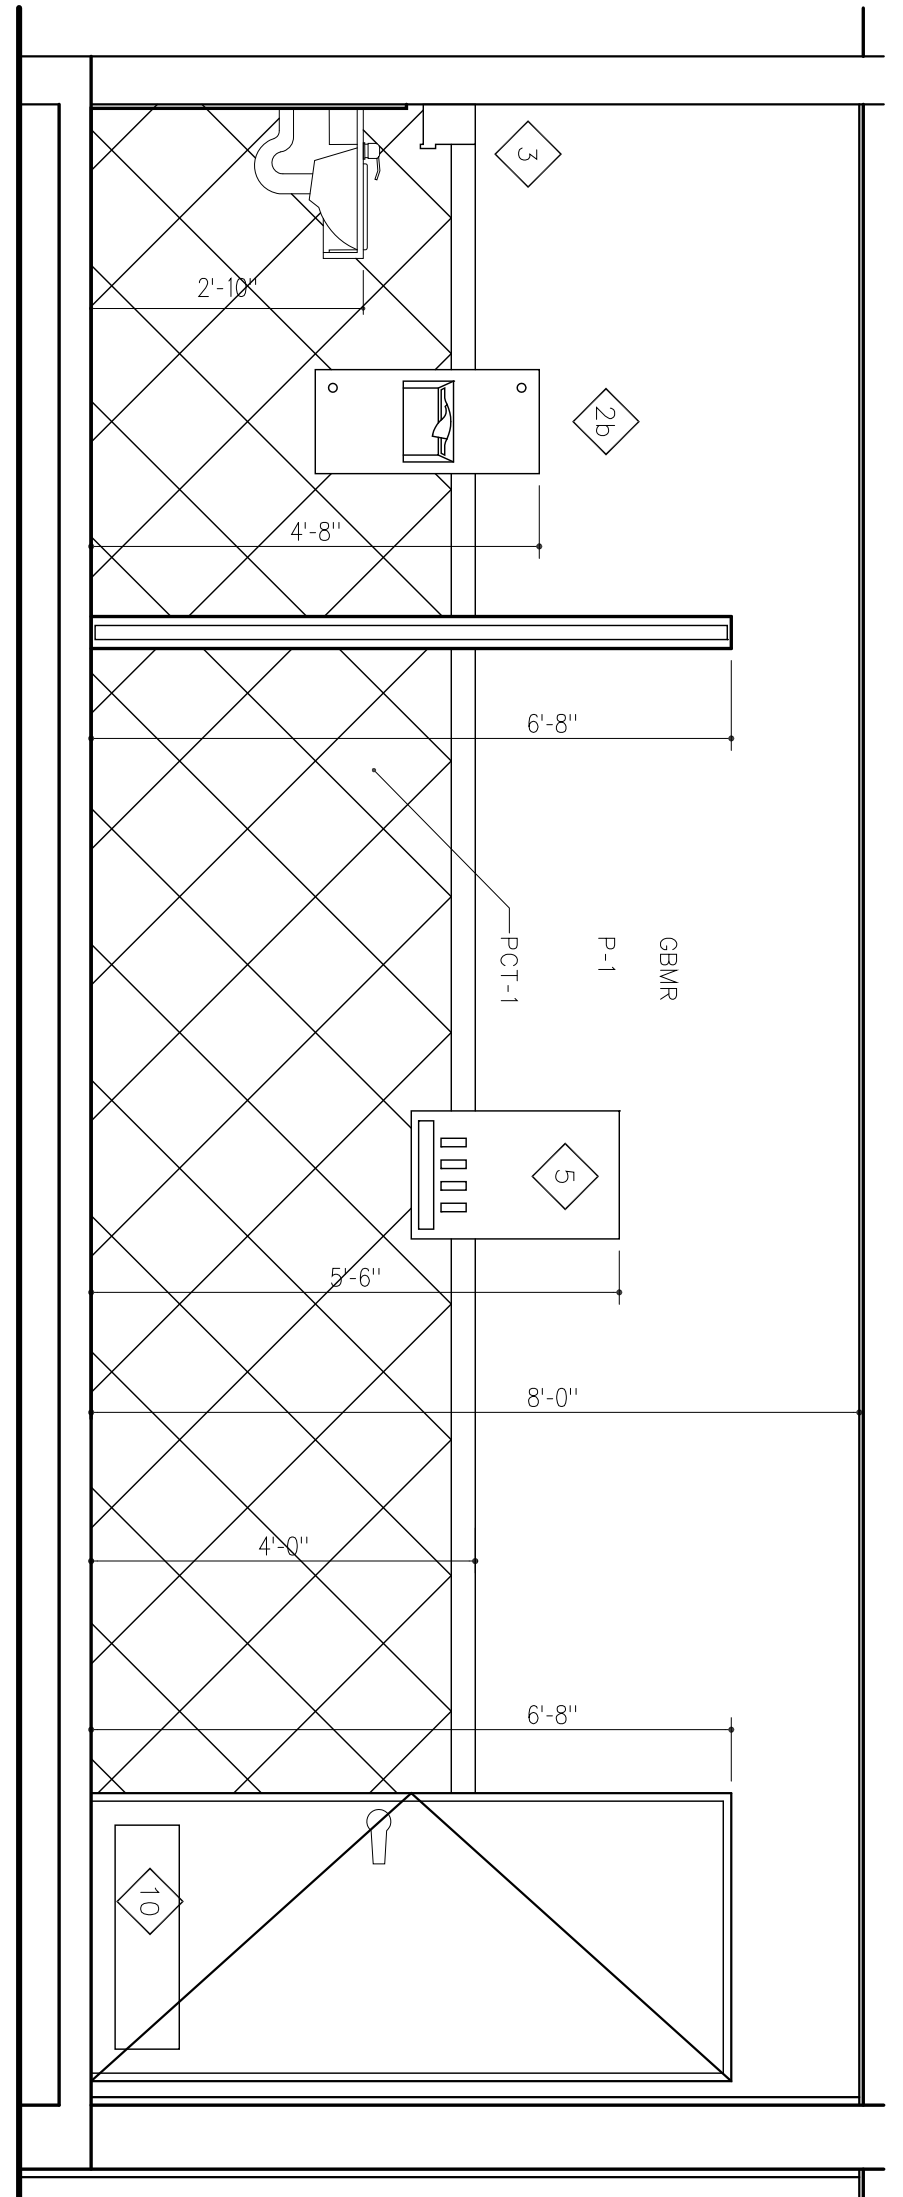
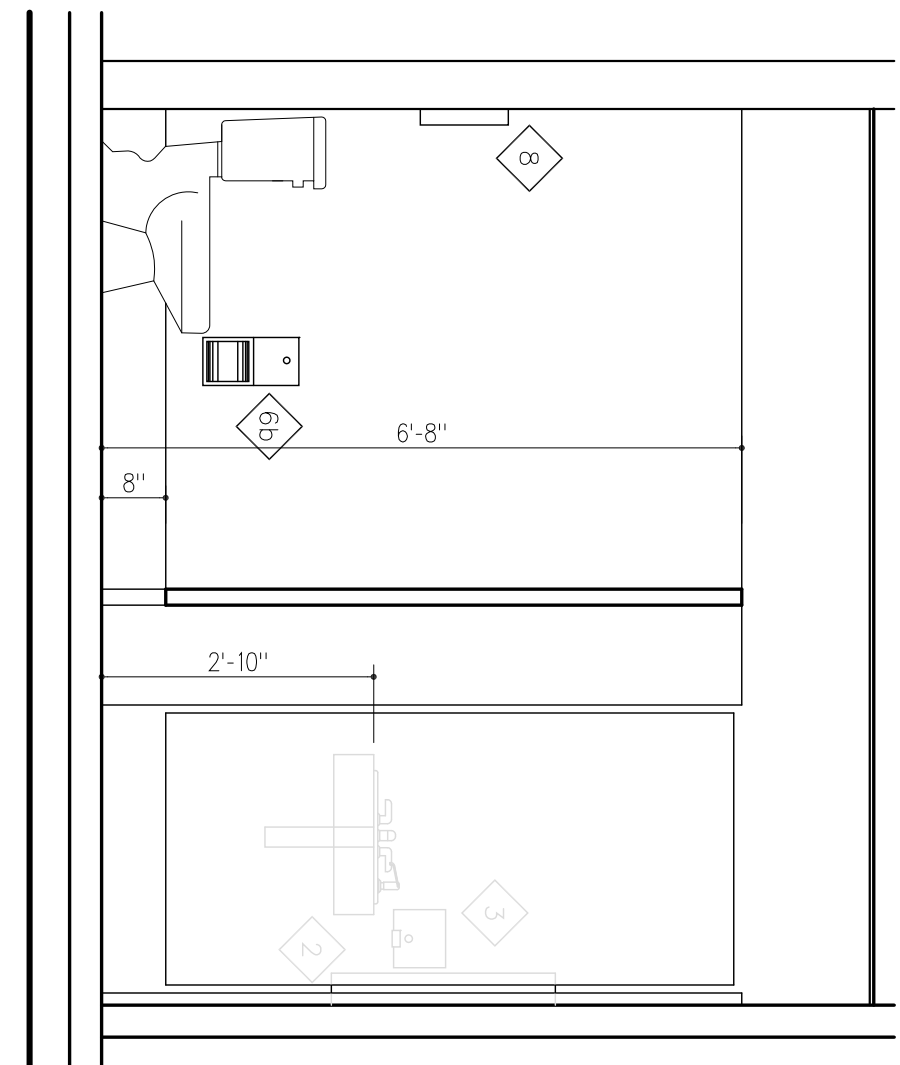
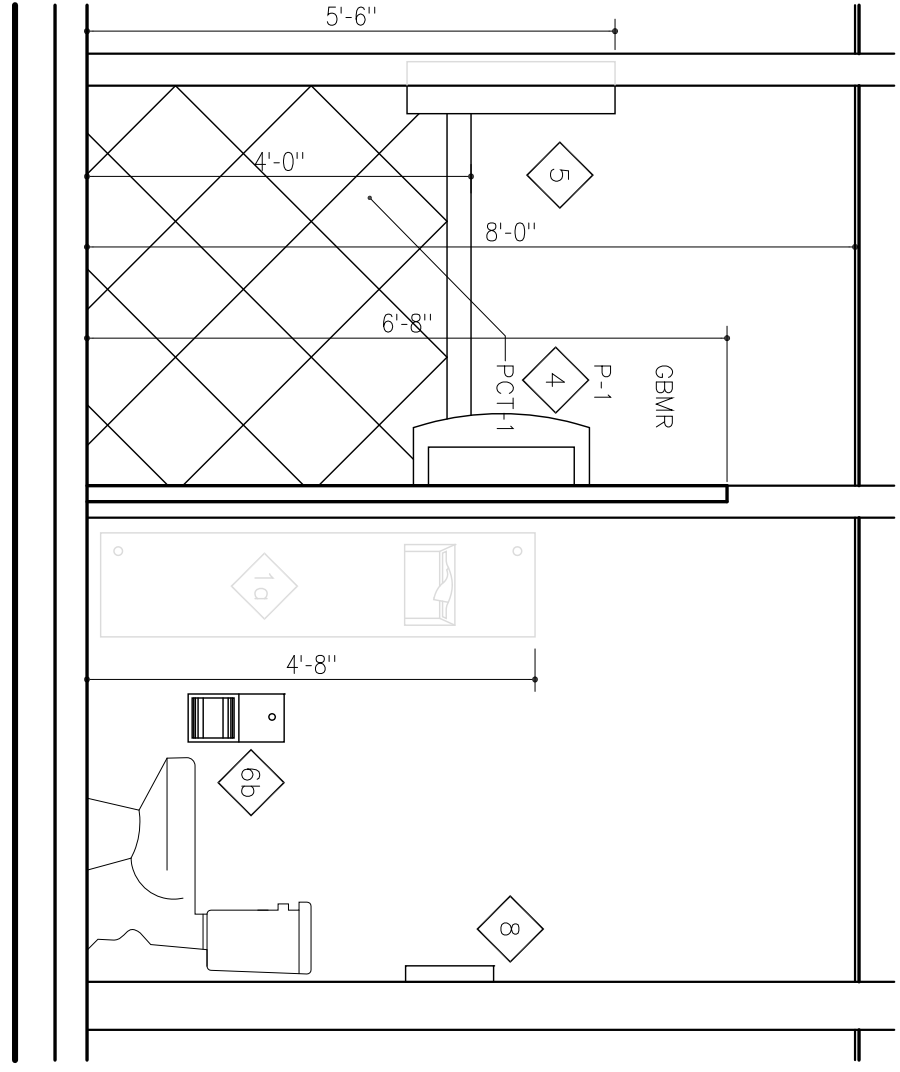
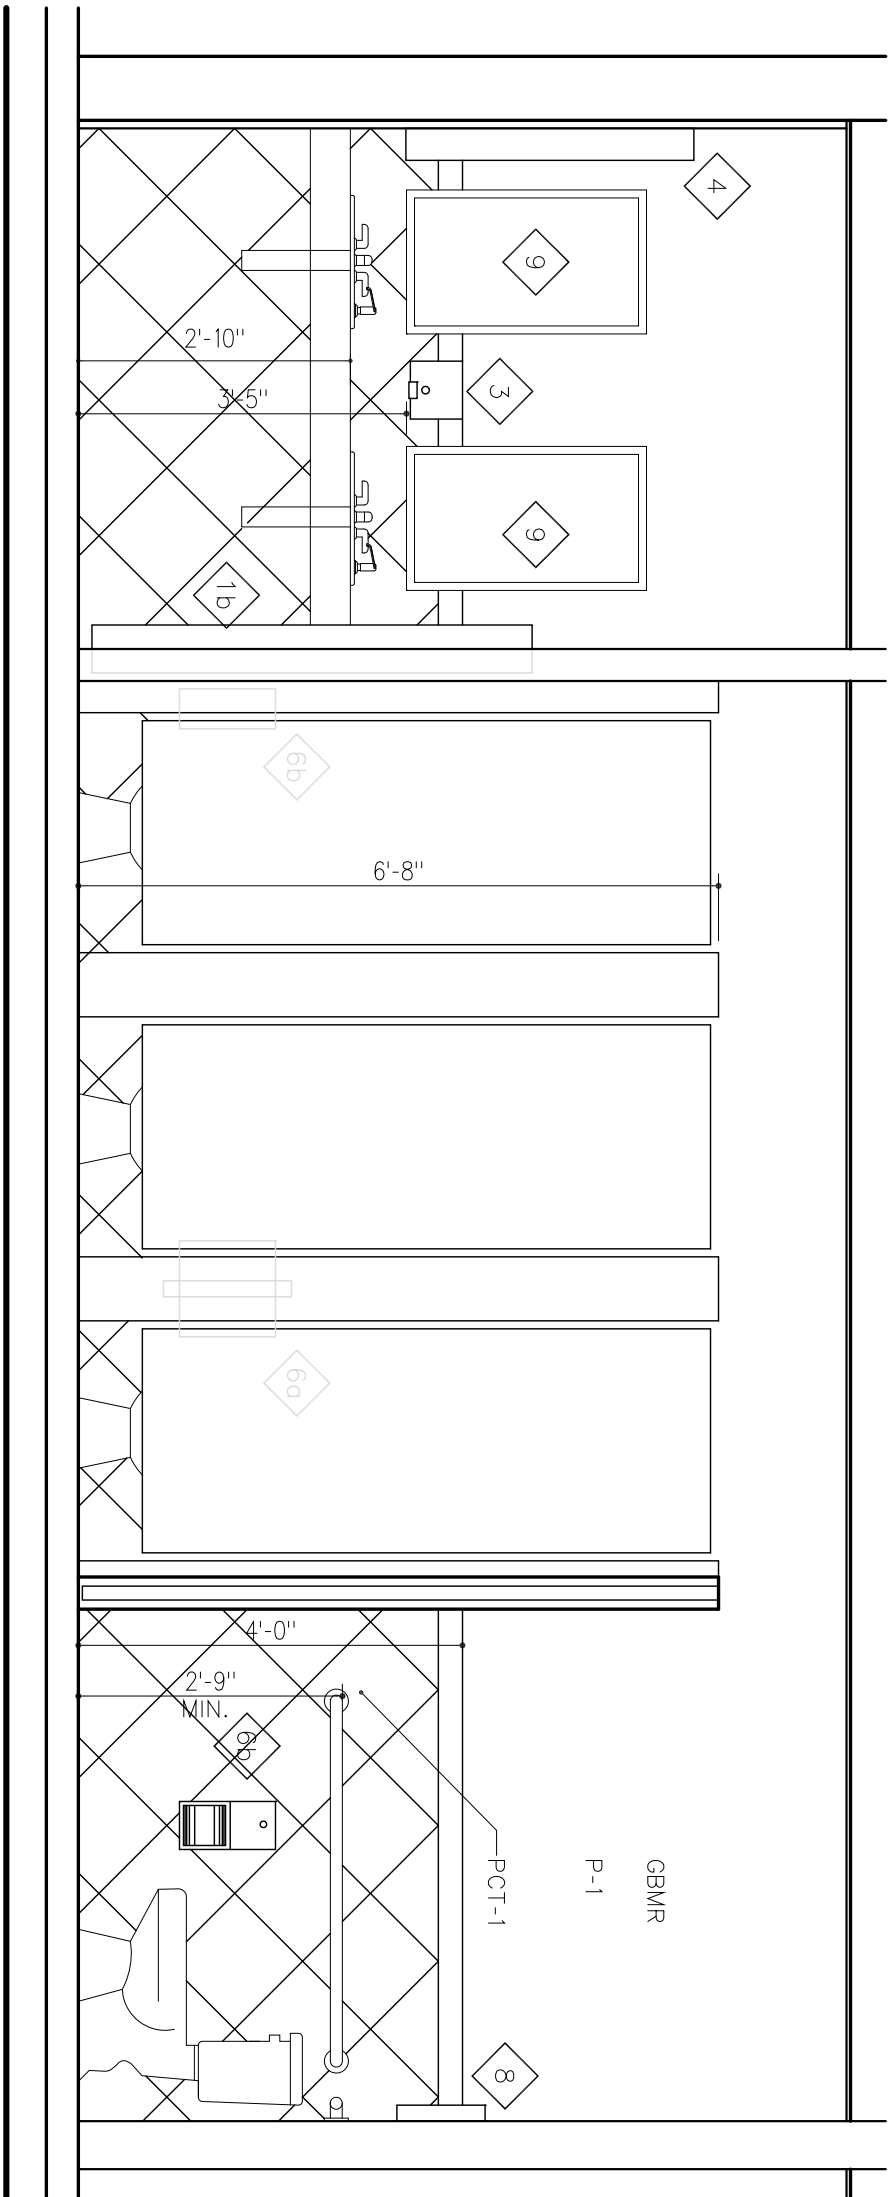
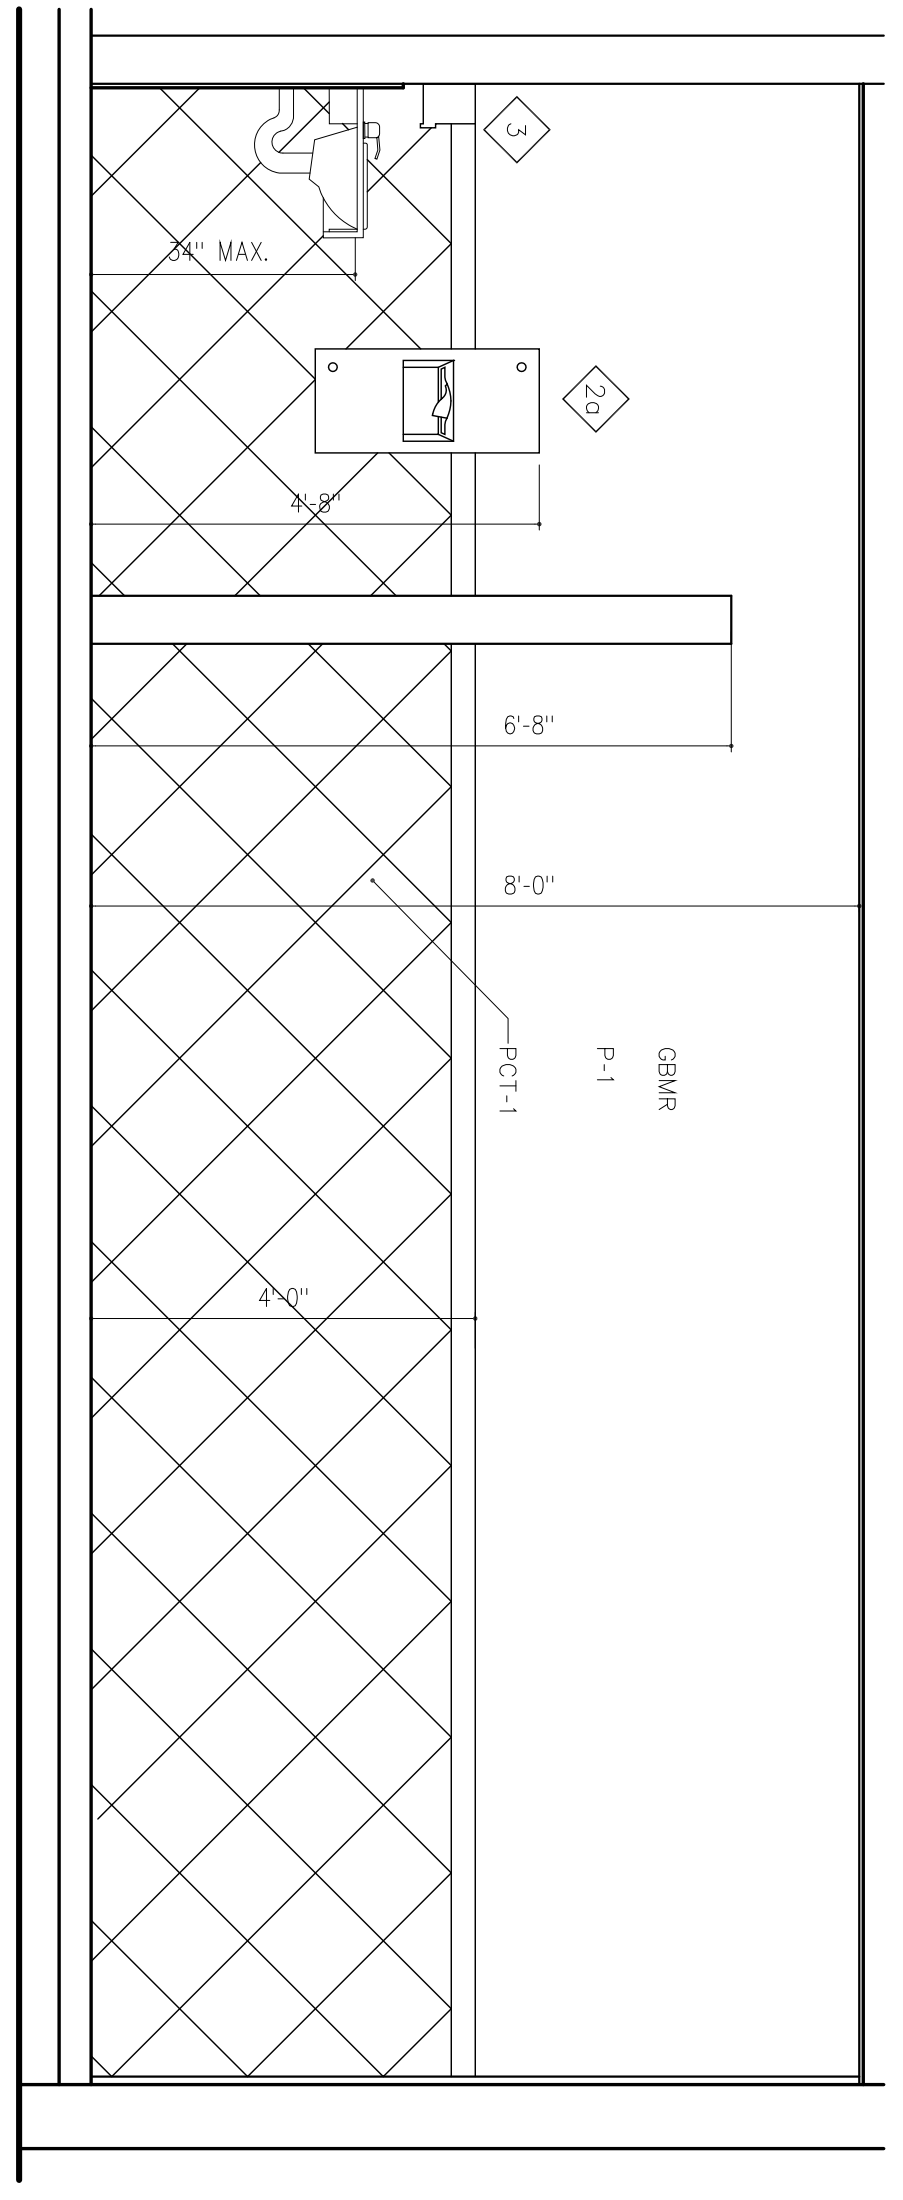
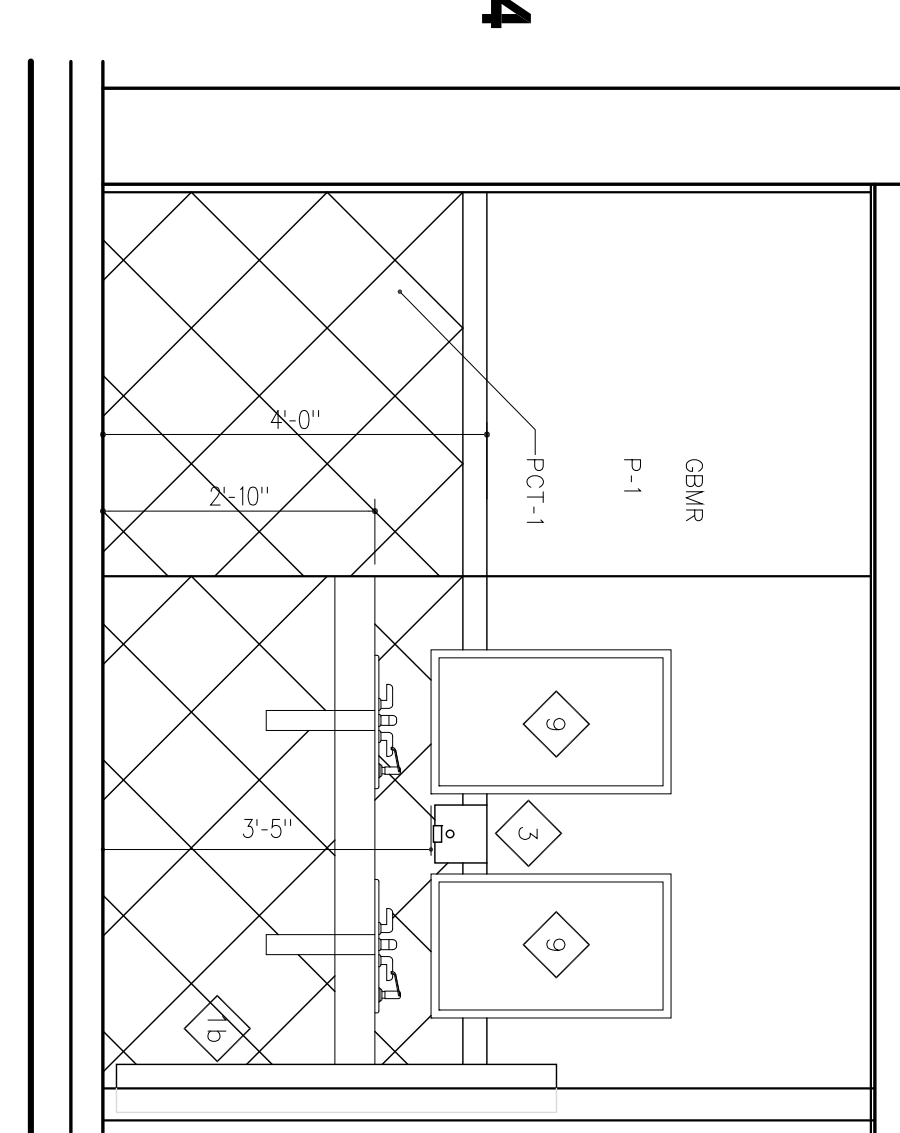


**2**  
**WOMEN BATHROOM**  
**ELEVATION BUILD. 2**  
SCALE: 1/2" = 1'-0"

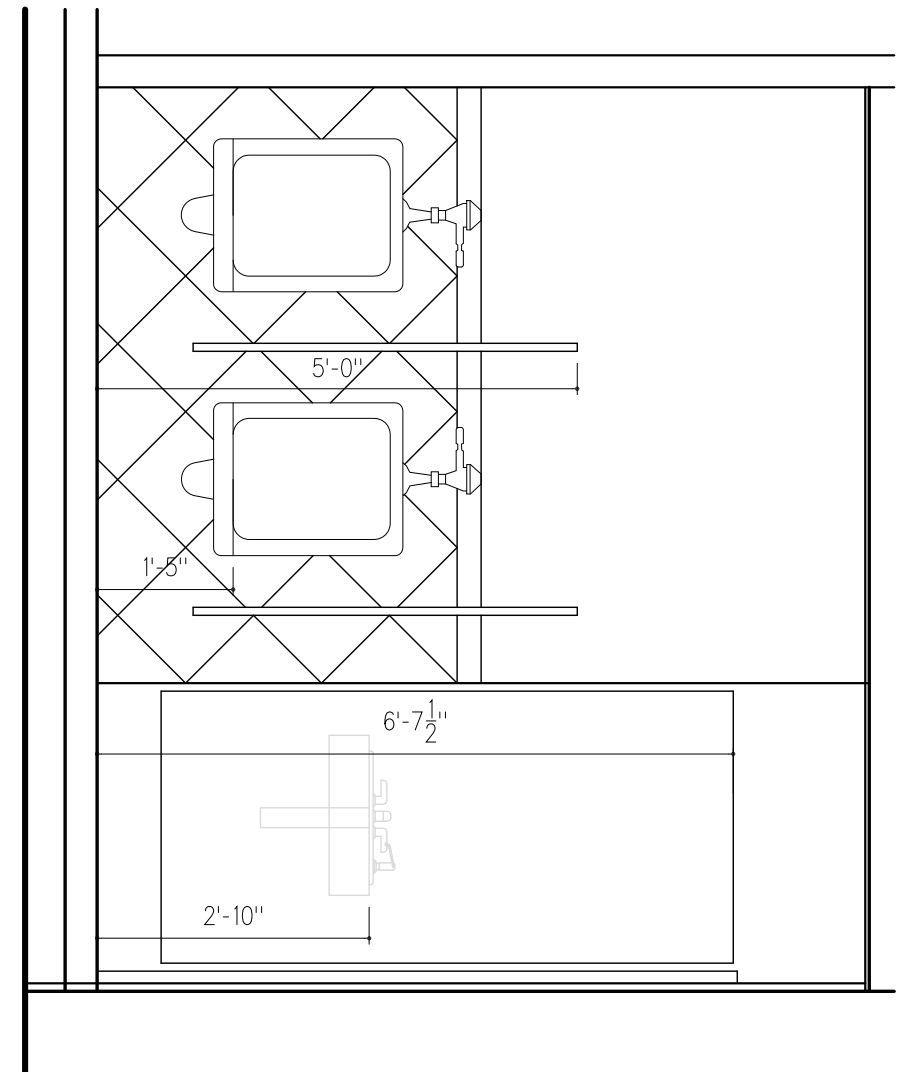

**1**  
**MEN RESTROOM**  
**ELEVATION BUILD. 2**  
SCALE: 1/2" = 1'-0"

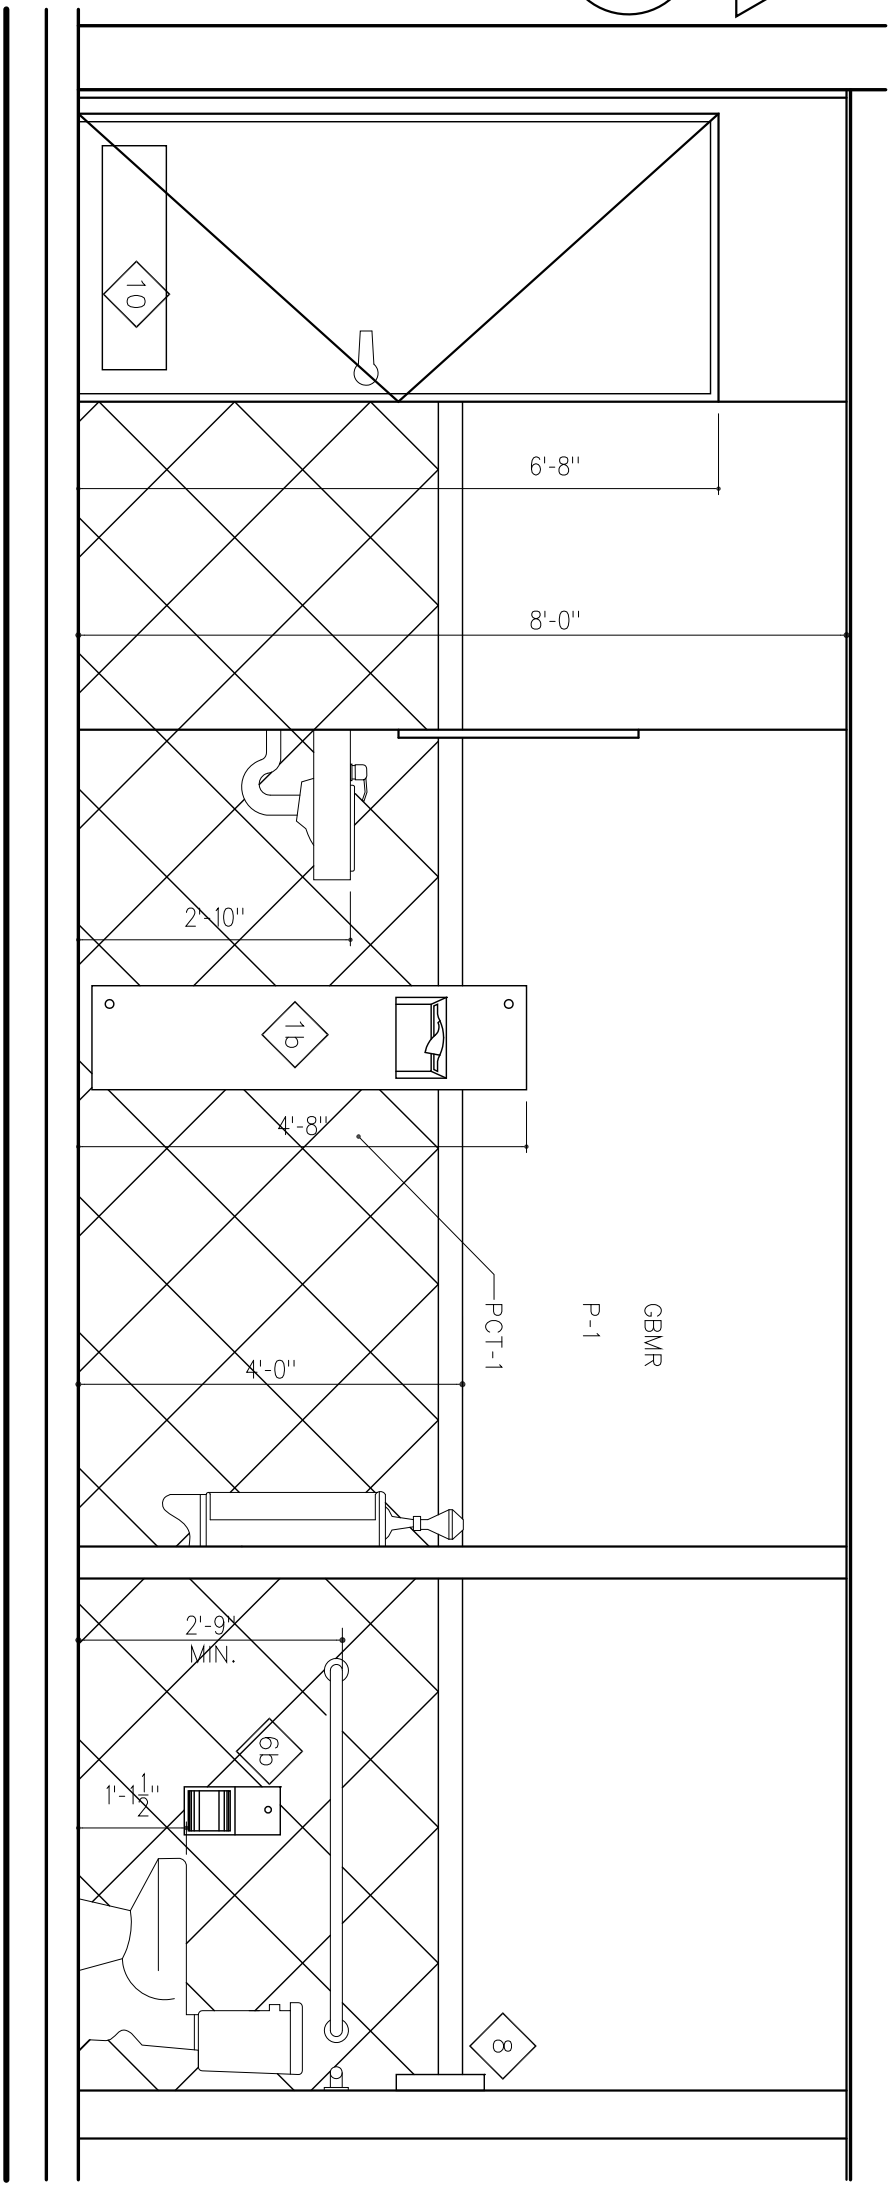

**NOTES:**

1. ACCESSIBLE WATER CLOSET DEPTH IS 30 INCHES AND IT IS FLOOR MOUNTED.
2. ACCESSIBILITY TO TOILET STALL DOOR IS IN COMPLIANCE WITH FACBC
3. TOILET ACCESSORIES TO BE APPROVED
4. IF PROVIDED, MIRRORS SHALL BE MOUNTED WITH THE BOTTOM ABOVE THE FINISH FLOOR SURFACE NO HIGHER AND HIGHER THAN 40 INCHES
5. ALL PIPES UNDER LAVATORIES SHALL BE INSULATED OR OTHERWISE CONFIGURED TO PROTECT AGAINST CONTACT WITH LAVATORIES.
6. ACCESSIBILITY TOILET STALL (COMPARTMENT) CAN BE 56" IN DEPTH IF YOU HAVE WALL MOUNTED WATER CLOSET. IF THE DEPTH OF A STANDARD STANDARD ACCESSIBLE TOILET STALL IS INCREASED AT 3 INCHES.
7. THE FRAME LIES BETWEEN THE FINISH SURFACE AND THE NON-SLIP MAT (NON-ABSORBENT) LIES ABOVE THE FINISH SURFACE. THE INTER-GAP (GAP) BETWEEN THE FRAME AND THE NON-SLIP MAT SHALL BE 4.0" ABOVE THE FIN. FLOOR. DIMENSIONS TO LOCATE PLUMBING FIXTURES ARE TO FINISHED SURFACE OF WALL
8. \*\* THE CENTER OF SINK SHALL BE A MINIMUM OF 15 INCHES FROM THE SIDE WALL AS OF THE PFC. FLOOR MOUNTED WATER CLOSET MAY BE USED. FOR VANITY MOUNTING HEIGHTS AND GRAB BAR DE MALS REFER TO A11-1/19, 1, 17 & 18

**LEGEND**

- 1 GAL. PAPER TOWEL DISPENSER AND WASTE RECEPTACLE (SURFACE MOUNTED 646/9-9)
- 7 GAL. PAPER TOWEL DISPENSER AND WASTE RECEPTACLE ( 4" RECESSED 646/6-2)
- 18 GAL. PAPER TOWEL DISPENSER AND WASTE RECEPTACLE (SURFACE MOUNTED 646/3-9)
- 18 GAL. PAPER TOWEL DISPENSER AND WASTE RECEPTACLE ( 4" RECESSED 646/2)
- HORIZONTAL SOAP DISPENSER (9443)
- BABY CHANGING STATION (SURFACE MOUNTED 9072)
- SANITARY MOPPING/TAMPON VENDOR (4" RECESSED 646/6)
- DUAL ACCESS PARTITION MOUNTED DUAL TOILET PAPER DISPENSER (0032)
- SURFACE MOUNTED DUAL ROLL TOILET PAPER DISPENSER (0030)
- HEAVY DUTY UTILITY HOOK (1306)
- SURFACE MOUNTED TOILET SEAT COVER DISPENSER (047/75W)
- MIRROR
- KICK PLATE

ALL TOILET ACCESSORIES BY AMERICAN SPECIALTIES INC. OR APPROVED EQUAL.