



 






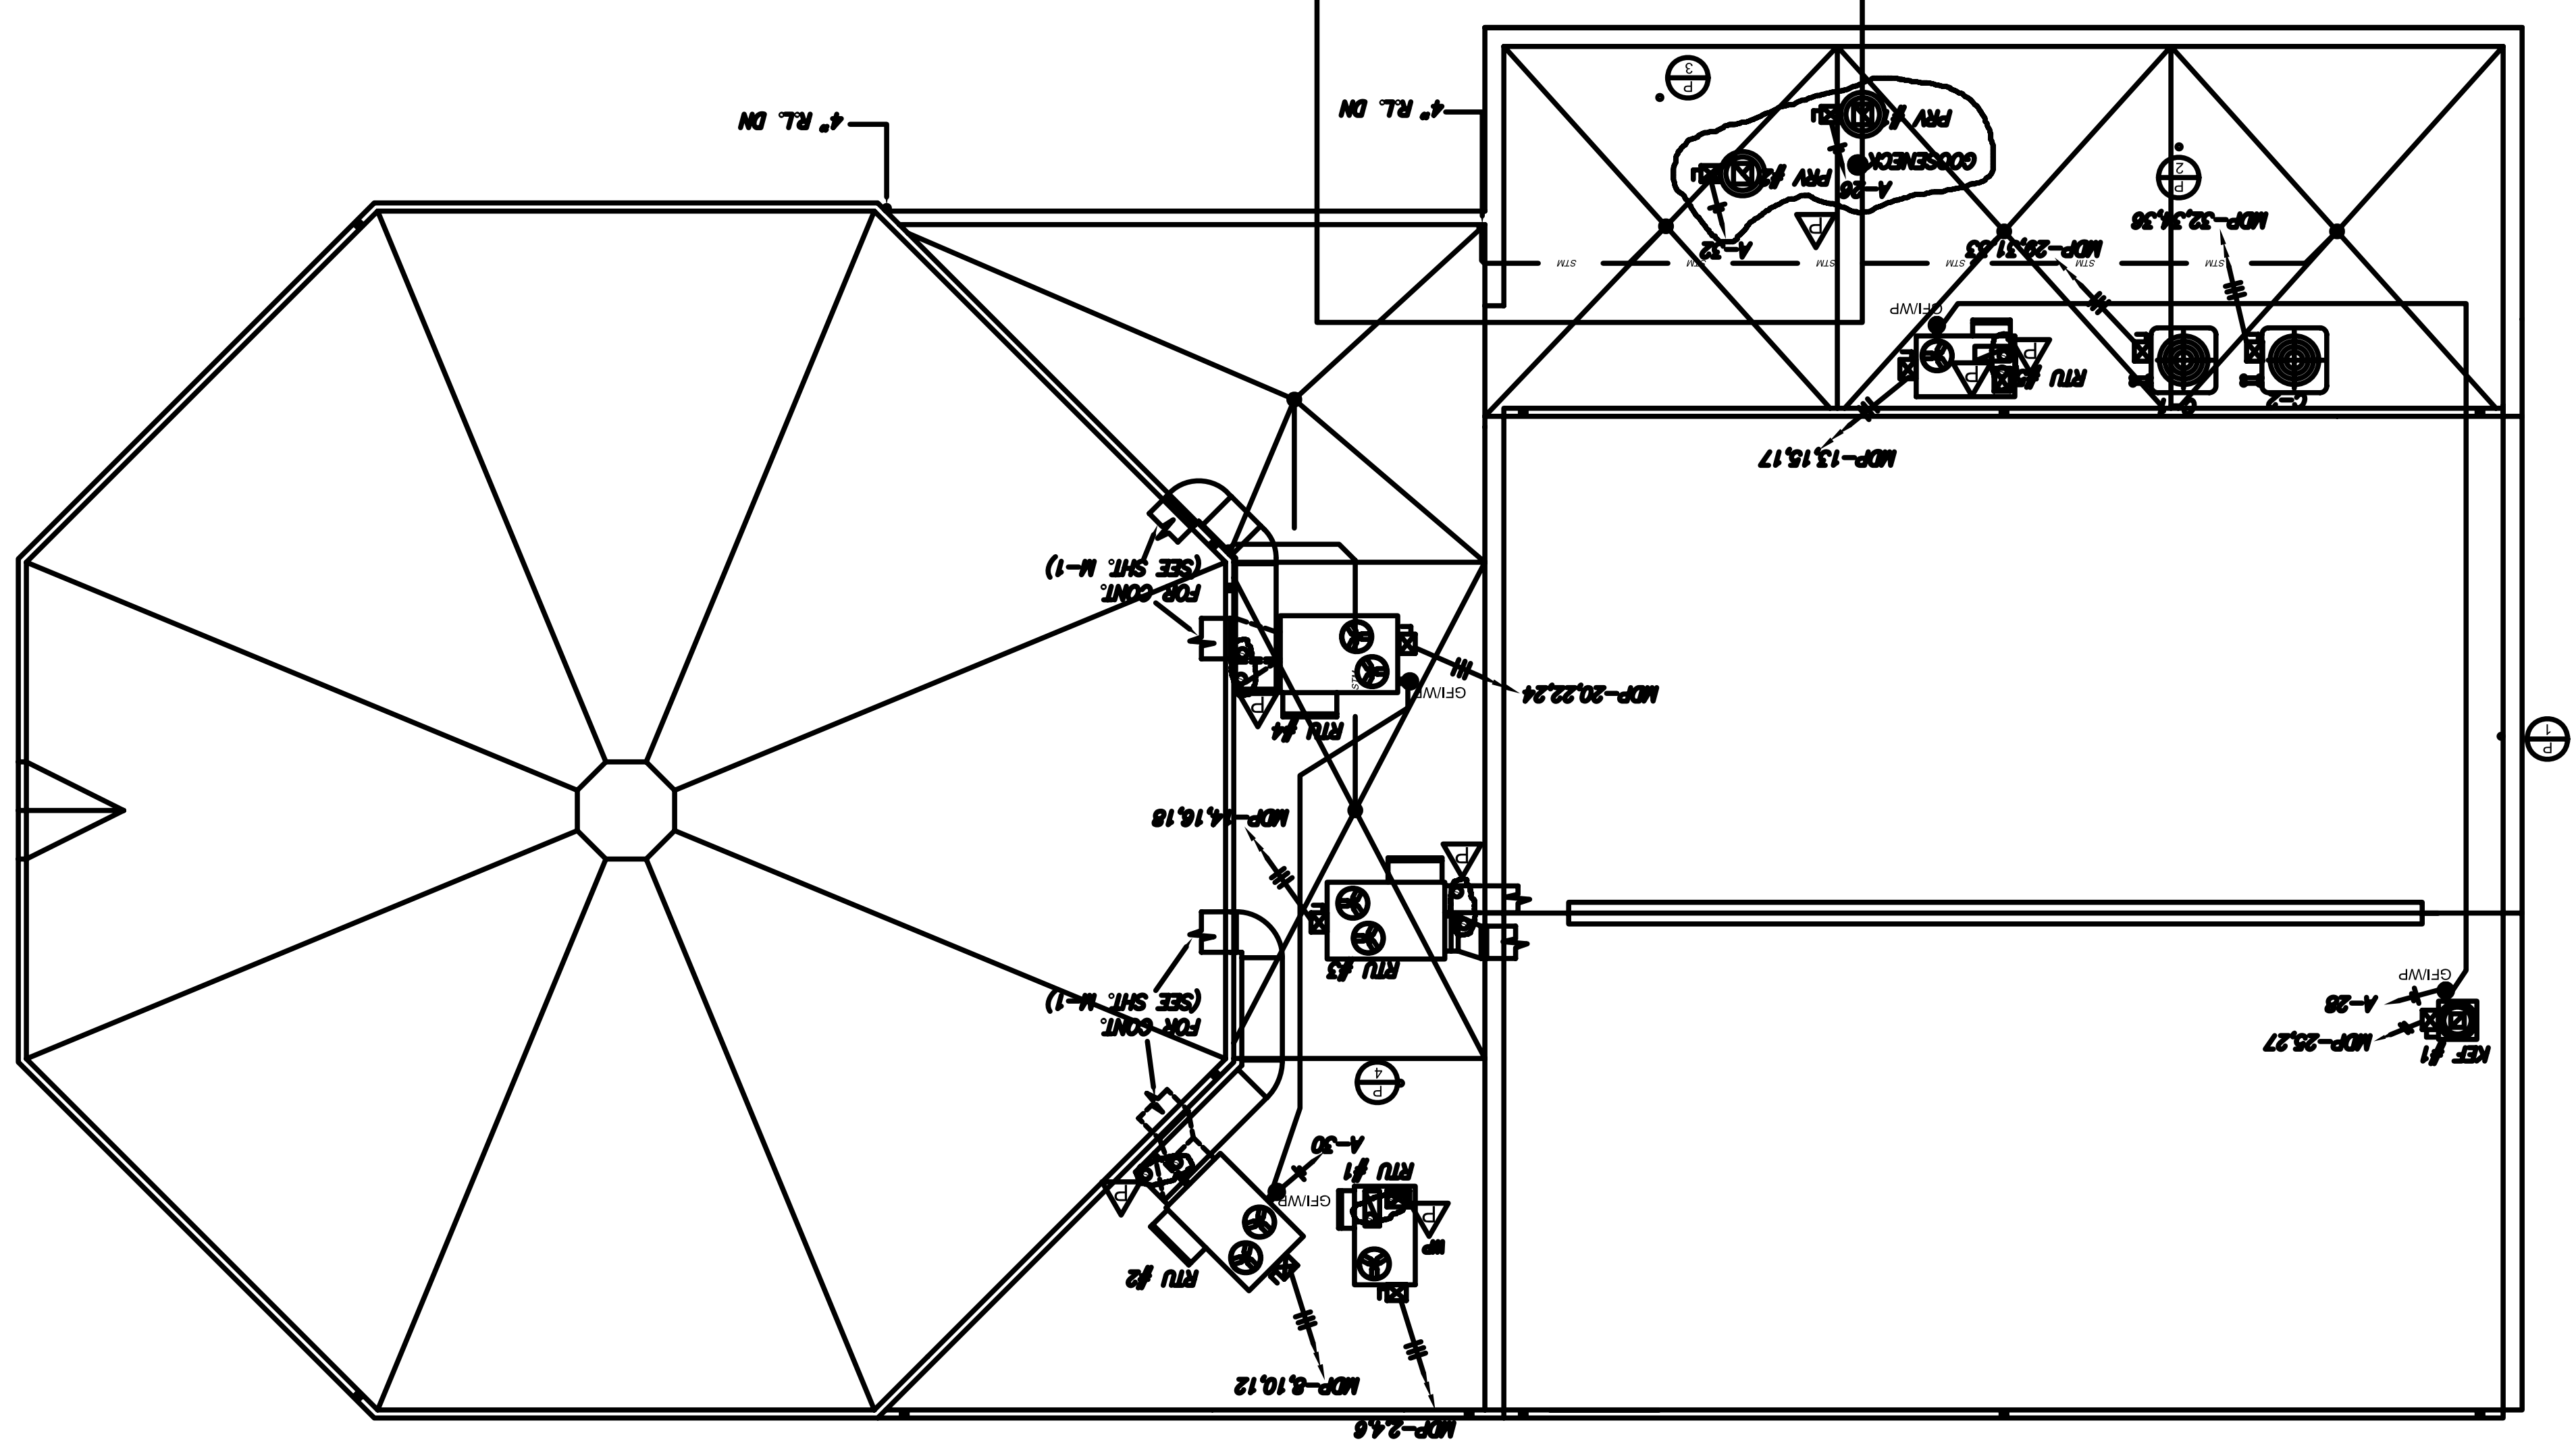

ROOF PLAN
SCALE 1/8"=1'-0"




SYMBOL LEGEND

-  AIR HANDLING UNIT
-  SUPPLY AIR DUCT
-  RETURN AIR DUCT
-  STORAGE DRAIN
-  WEATHERPROOF DUPLEX RECEPTACLE OUTLET
-  GROUND FAULT INTERRUPTER (GFI) (NEMA 5-30V)
-  DISCONNECT SWITCH - CONTROLLER COMPARTMENT IN NEAR 3R ENCLOSURE
-  BRANCH CIRCUIT BREAKER TO PANELBOARD, NUMBER OF PANELS AND NUMBER OF CIRCUITS, FULL VOLTAGES
-  EQUIPMENT GROUNDING CONDUCTOR
-  BRANCH CIRCUIT WIRING IN R.M.C.

Drawing No. MEP-1

File No. BETHLA01
Checked: C.FORD
Drawn: PAL
Scale: 1/8"=1'-0"
Date: NOV. 29, 2005

Philip Aaron Lacy, Architect
4013 21st. Place
Temple Hills, Maryland 20748
Phone: 301-894-7979

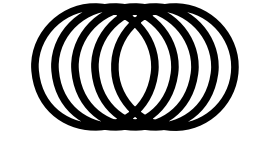

Project Title:
BETH SHALOM A.M.E. ZION CHURCH
2501 RITCHIE ROAD
DISTRICT HEIGHTS, MARYLAND 20735
ROOF PLAN

Certification:

Engineer:
CHARLES FORD & ASSOCIATES
CONSULTING - ARCHITECTURE & PLANNING
4400 GREENWAY AVE., SUITE 100, WASHINGTON, D.C. 20004-1000
(202) 739-1400

Revisions:	Date:
ASBENT COMPLIANCE	10-05-07