

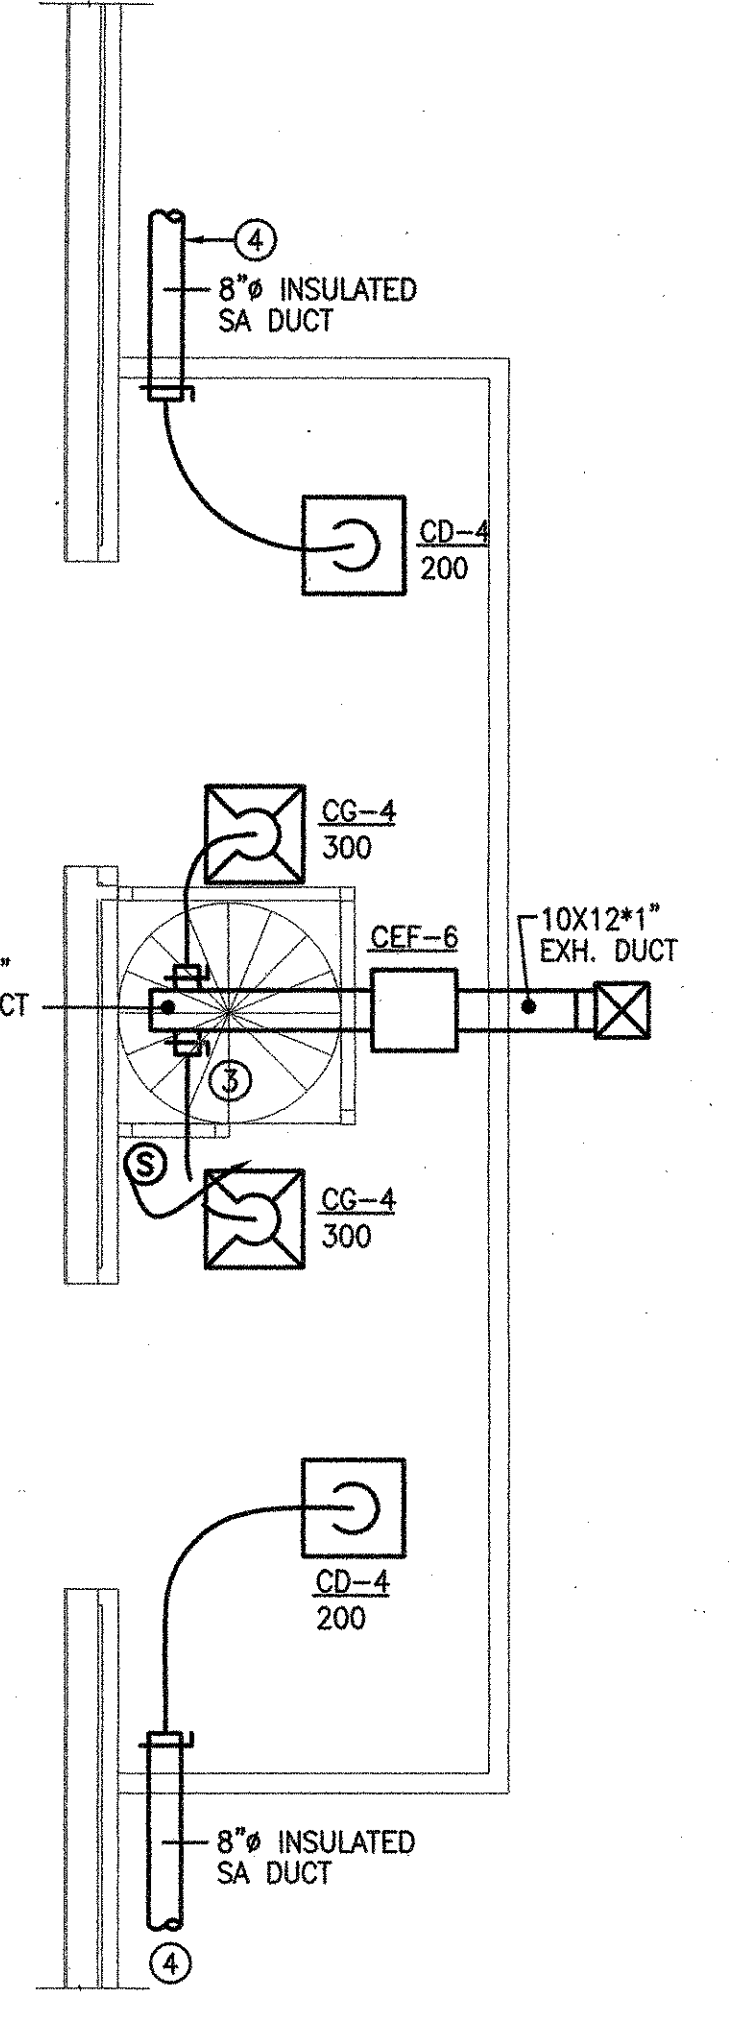


Copyright 2005 Philip Aaron Lacy, Architect. All rights reserved. No portion of this document may be reproduced without written permission.

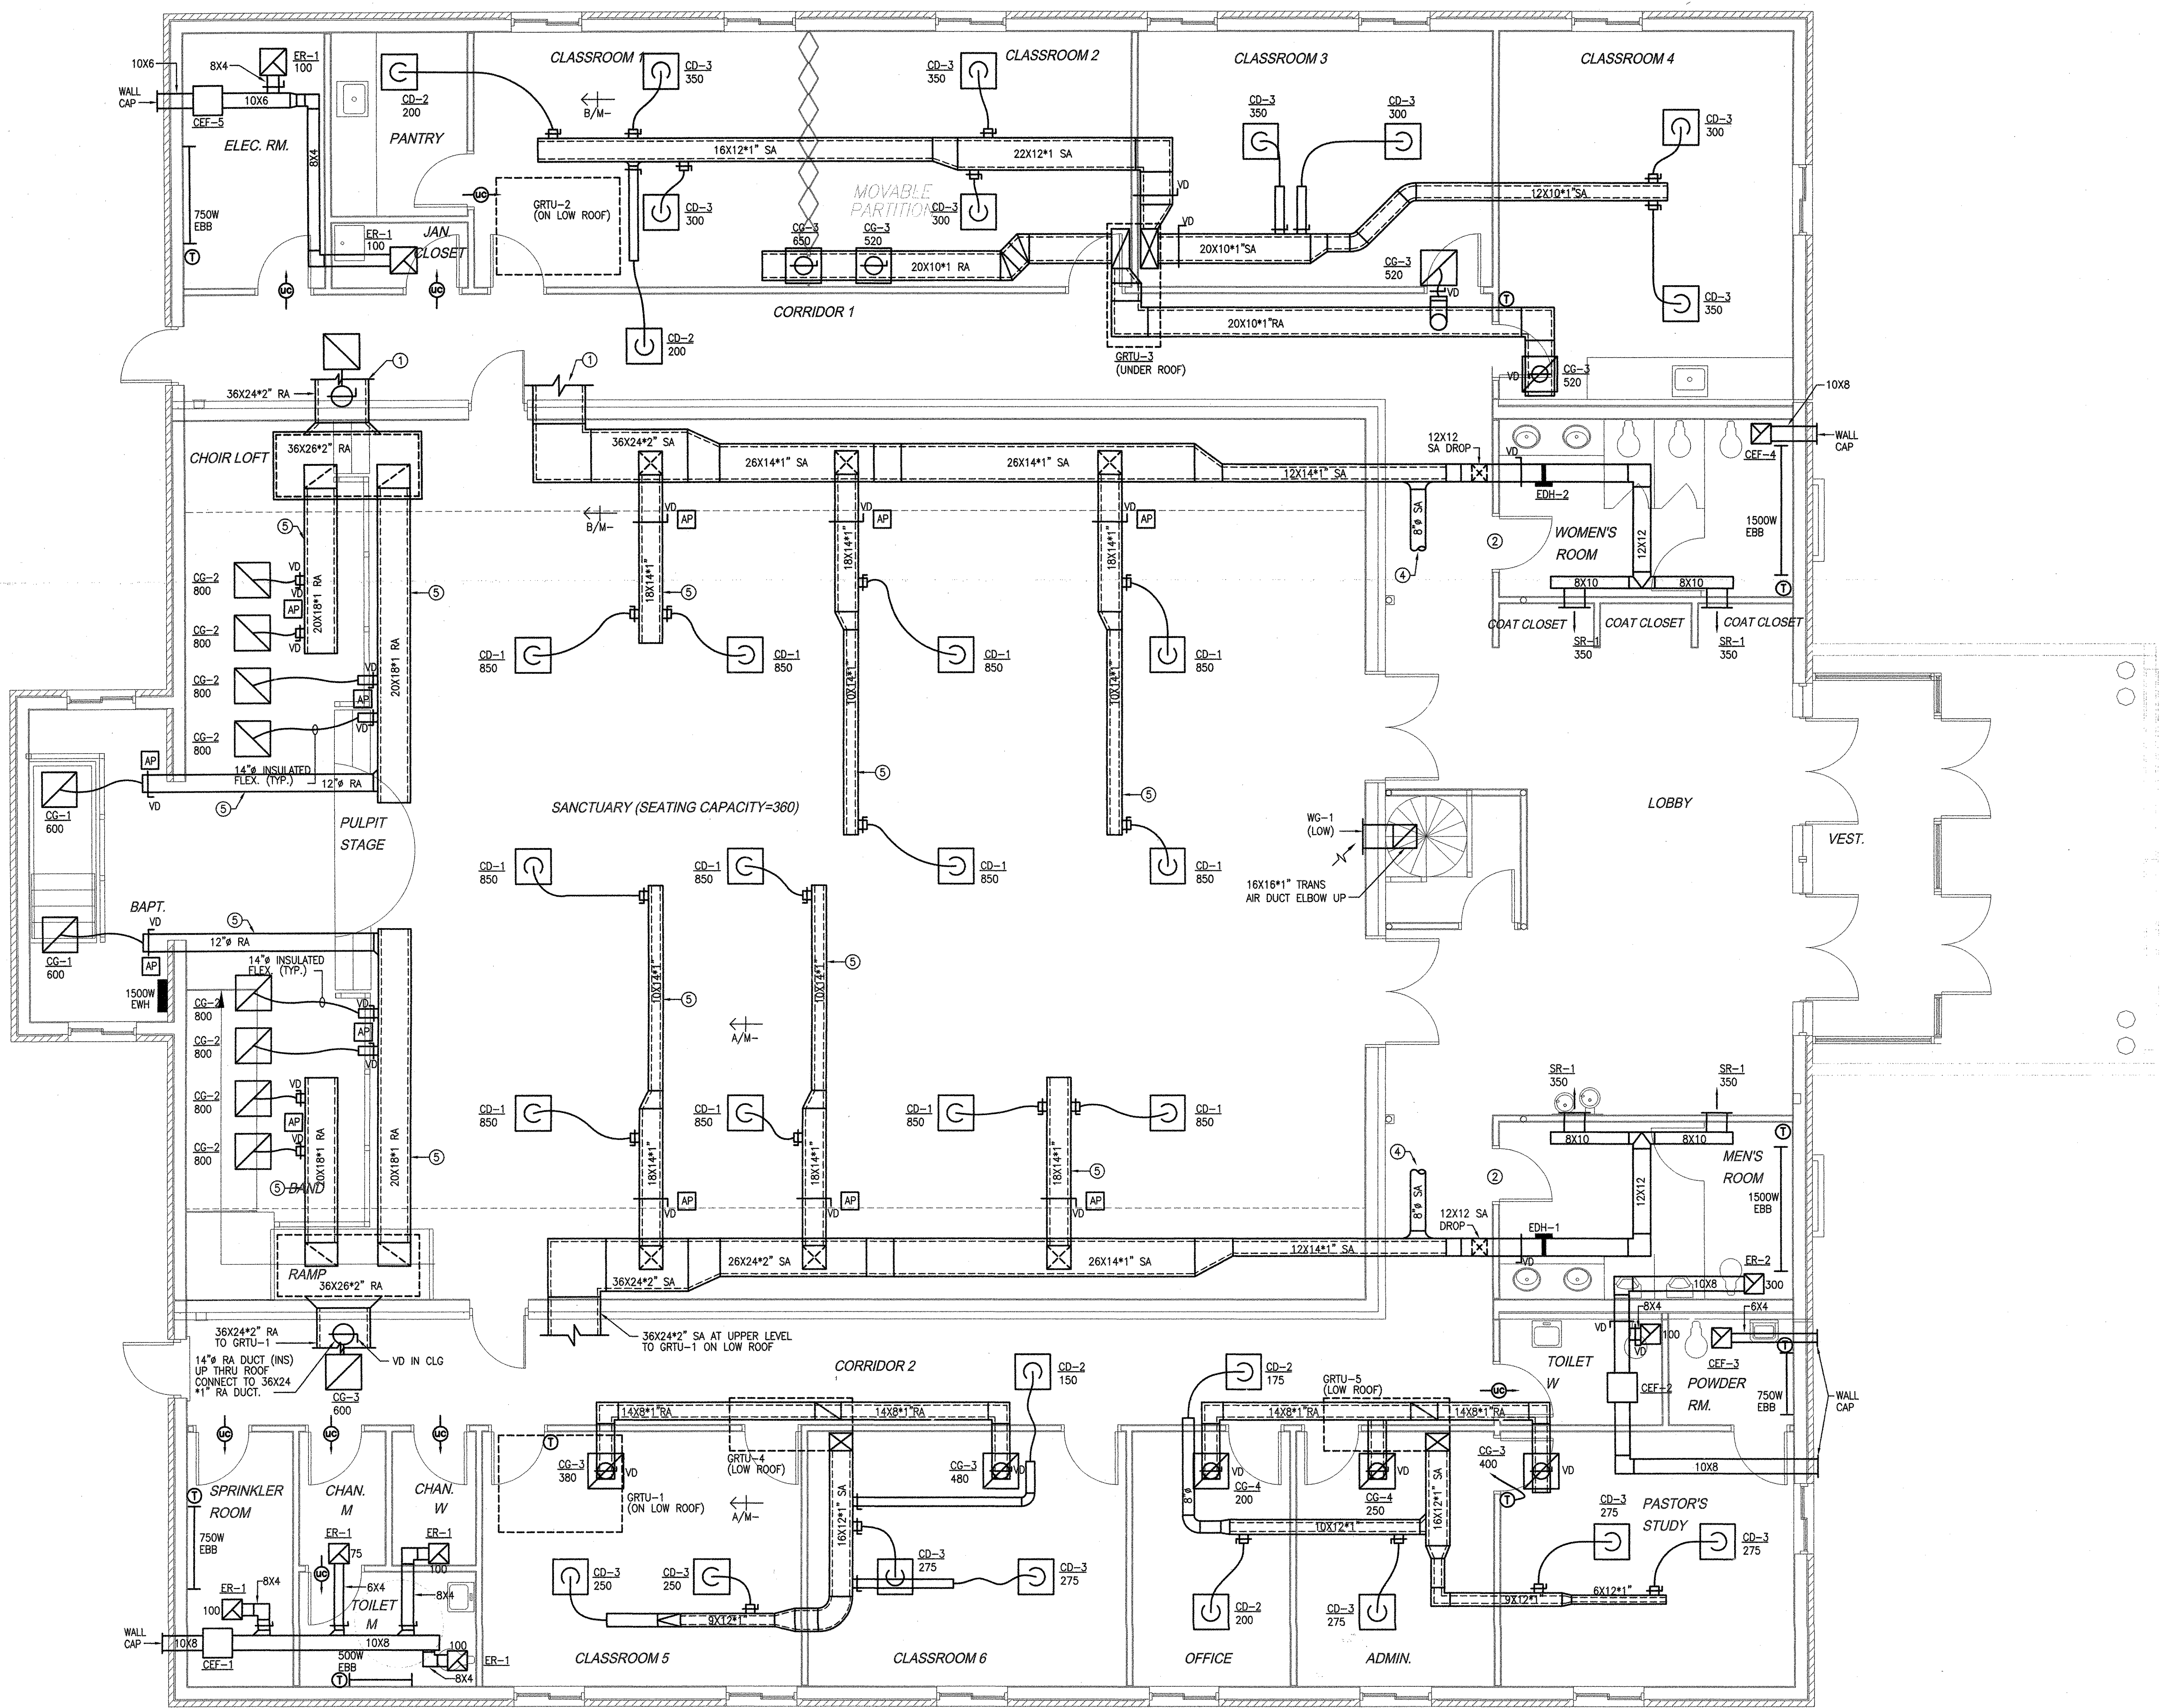


MECHANICAL PLAN (MEZZANINE)
SCALE: 1/4" = 1'-0"

MECHANICAL PLAN
SCALE: 1/4" = 1'-0"

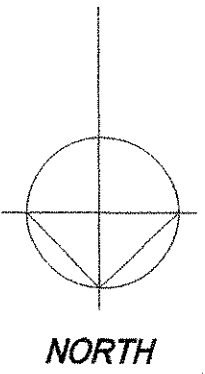

Date:	
Revisions:	

Consultants:

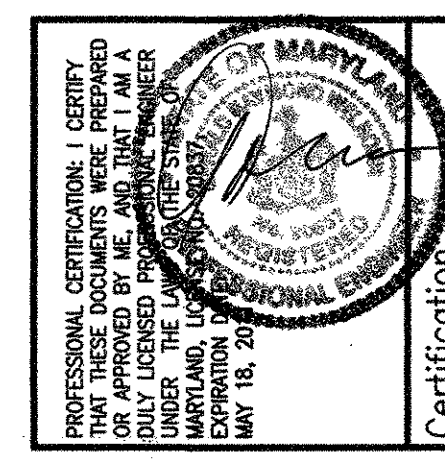

Project Title:
MIRACLE TEMPLE ASSEMBLY OF GOD
14111 ALBERTON ROAD
SILVER SPRING, MARYLAND 20908

MECHANICAL PLAN

Philip Aaron Lacy, Architect
6188 Oxon Hill Road, Suite 303
Oxon Hill, Maryland 20745
Phone: 301-567-8223

Date:	OCTOBER 12, 2010
Scale:	1/4" = 1'-0"
Drawn:	GC
Checked:	CC
File No.:	P:\PROJ\2010\10003

Drawing No.
M - 2
of

