


Copyright 2005 Philip Aaron Lacy, Architect. All rights reserved. No portion of this document may be reproduced without written permission.

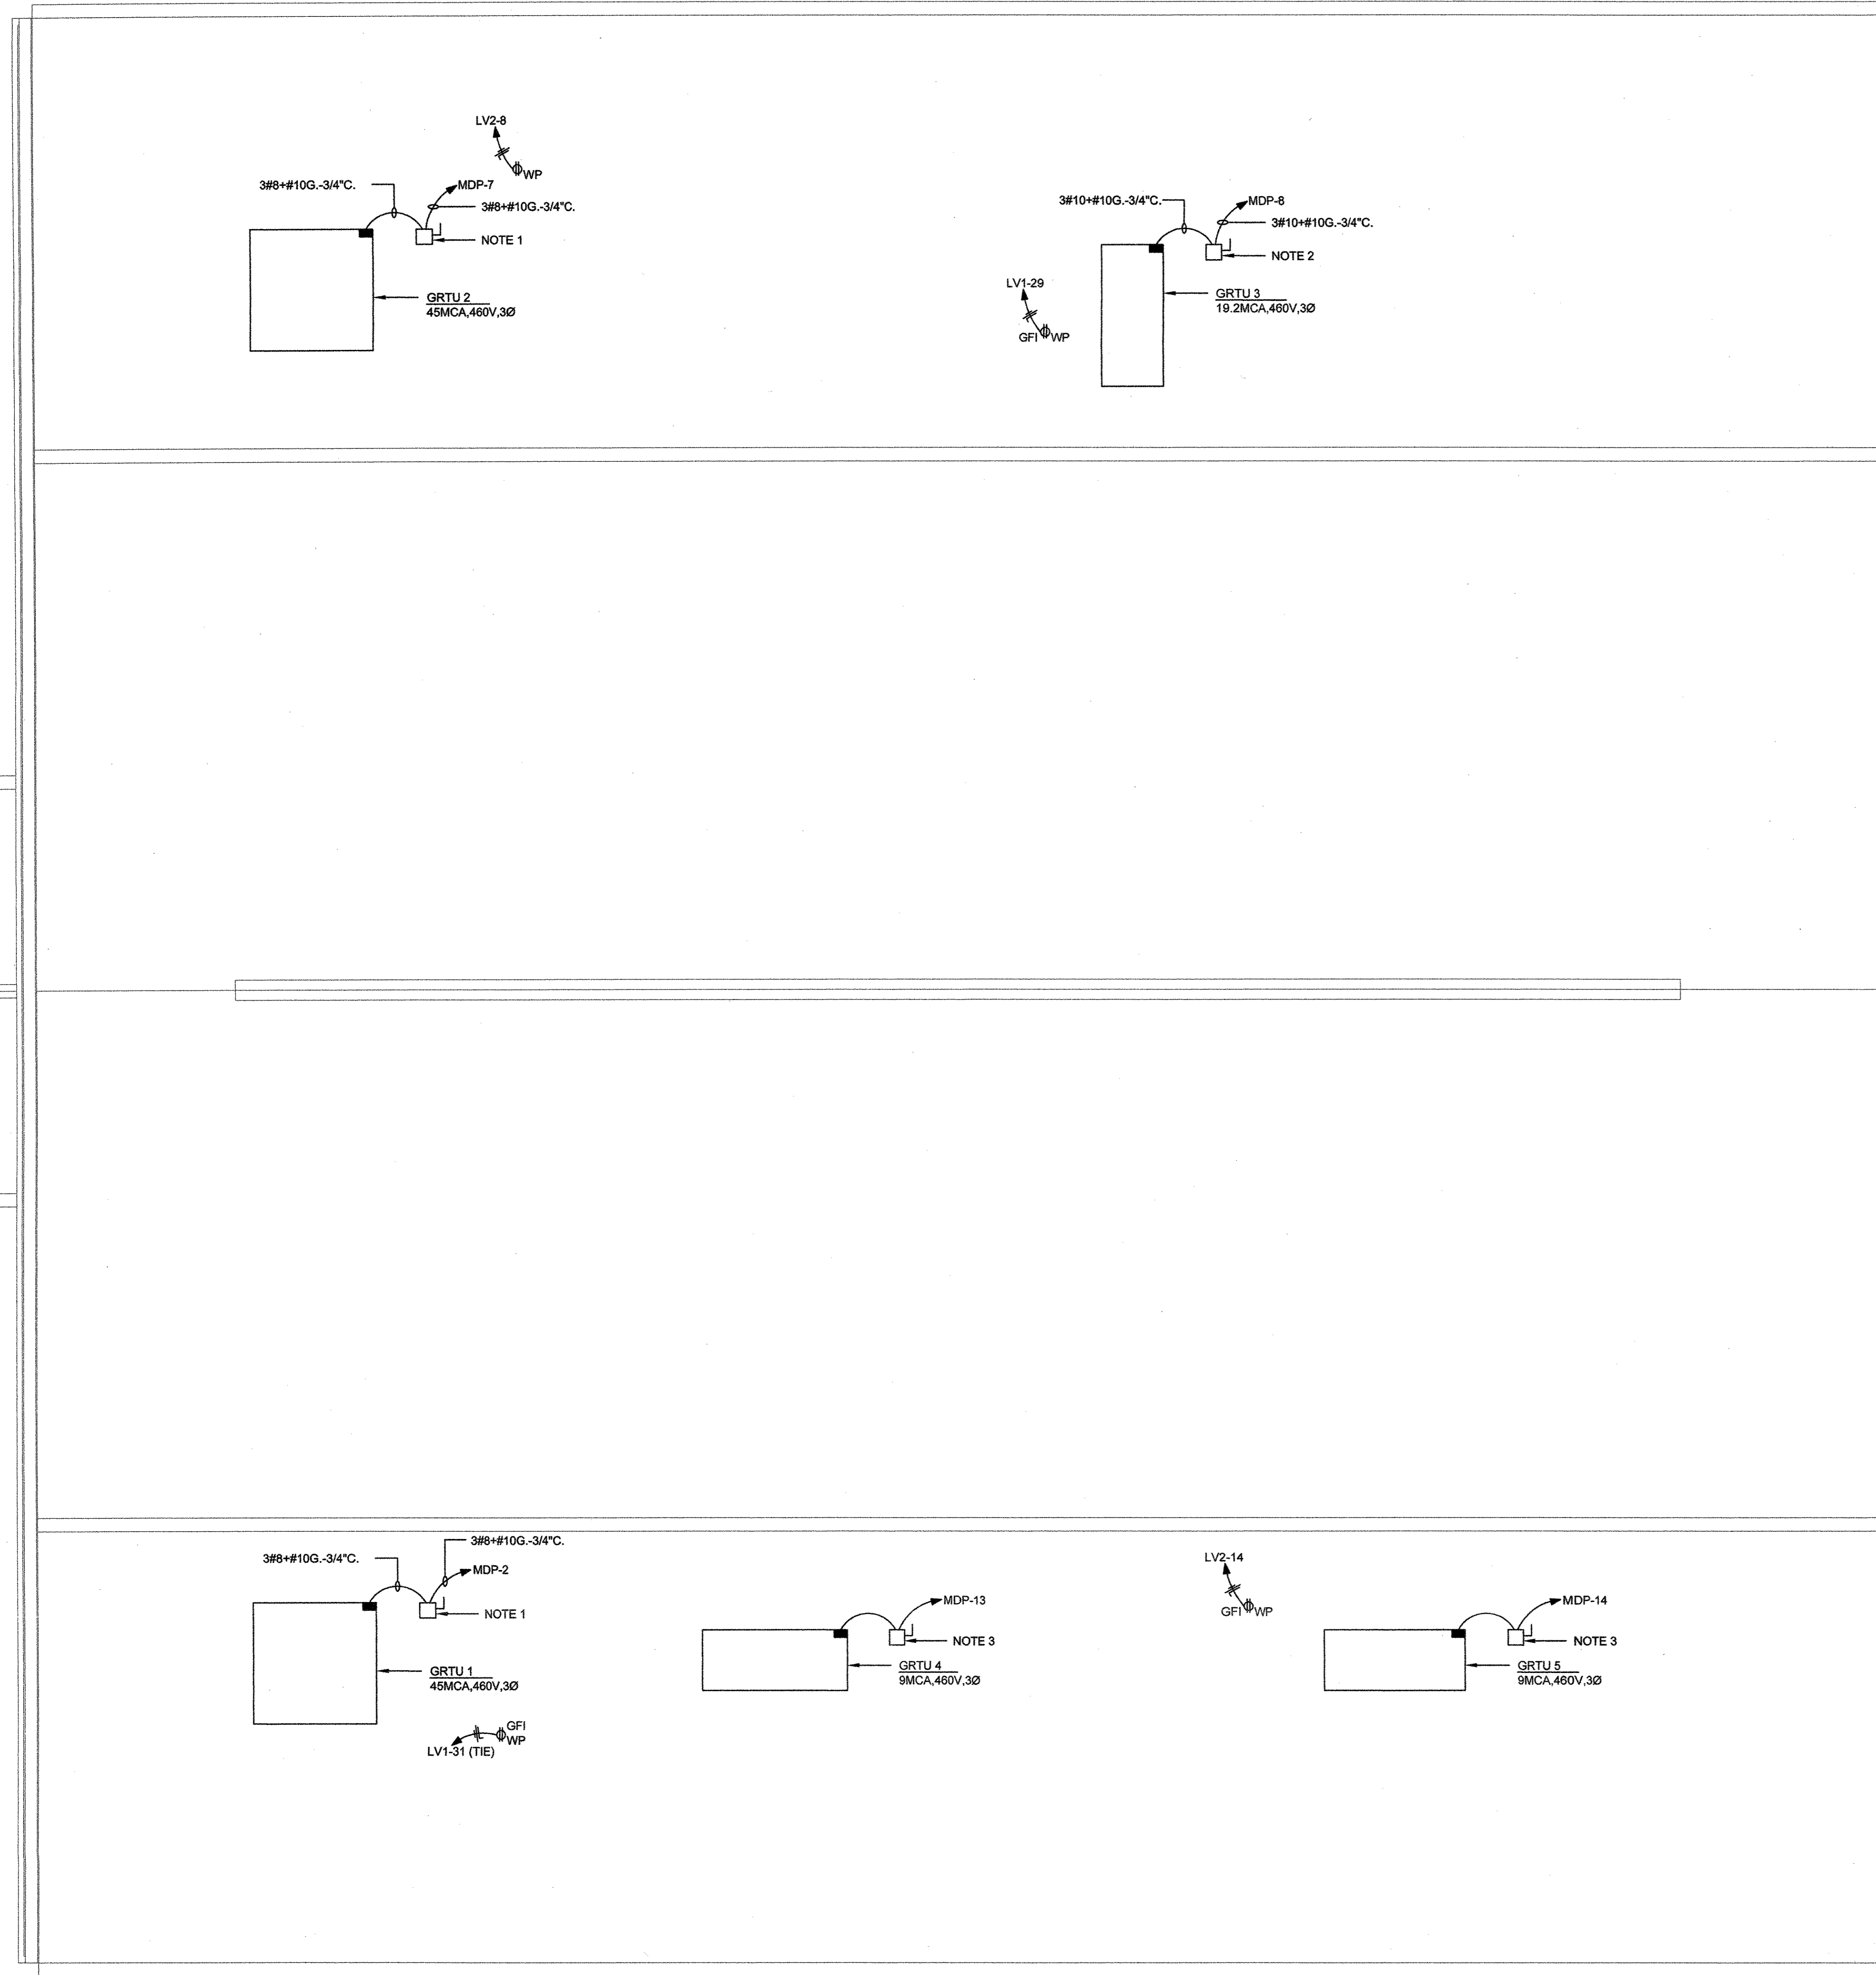


**POWER PLAN NOTES**

- 1. FSS, 3PST, HD, 480VAC, 60A, FUSED @ 50A, NEMA 3R.
- 2. FSS, 3PST, HD, 480VAC, 30A, FUSED @ 25A, NEMA 3R.
- 3. FSS, 3PST, HD, 480VAC, 30A, FUSED @ 15A, NEMA 3R.

**ROOF PLAN**  
SCALE: 1/4" = 1'-0"  
NORTH

Date:	
Revisions:	
Consultants:	

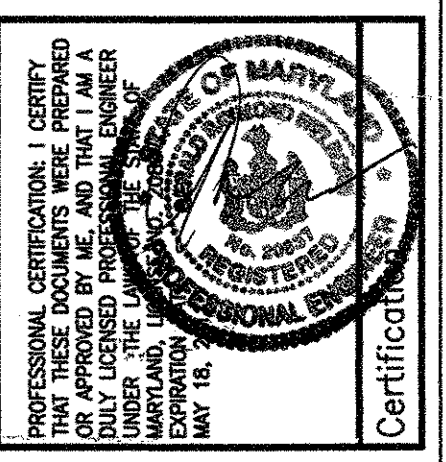

Project Title:  
**MIRACLE TEMPLE ASSEMBLY OF GOD**  
14111 ALBERTON ROAD  
SILVER SPRING, MARYLAND 20908

ROOF PLAN

Philip Aaron Lacy, Architect  
6188 Oxon Hill Road, Suite 303  
Oxon Hill, Maryland 20745  
Phone: 301-567-8223

Date: **OCTOBER 12, 2010**  
Scale: **1/4" = 1'-0"**  
Drawn: **ST**  
Checked: **RW**  
File No.: **PROJ201010003**

Drawing No.  
**E-4**  
of

