


COPYRIGHT - 2008 - RAMOSMARTINEZ architects, inc. All ideas, designs and details indicated or represented by this drawing, created and developed for use on this project, are owned by, and are legal property of RamosMartinez Architects, Inc. Use, reproduction, distribution or alteration is prohibited without written authorization from the Architect.

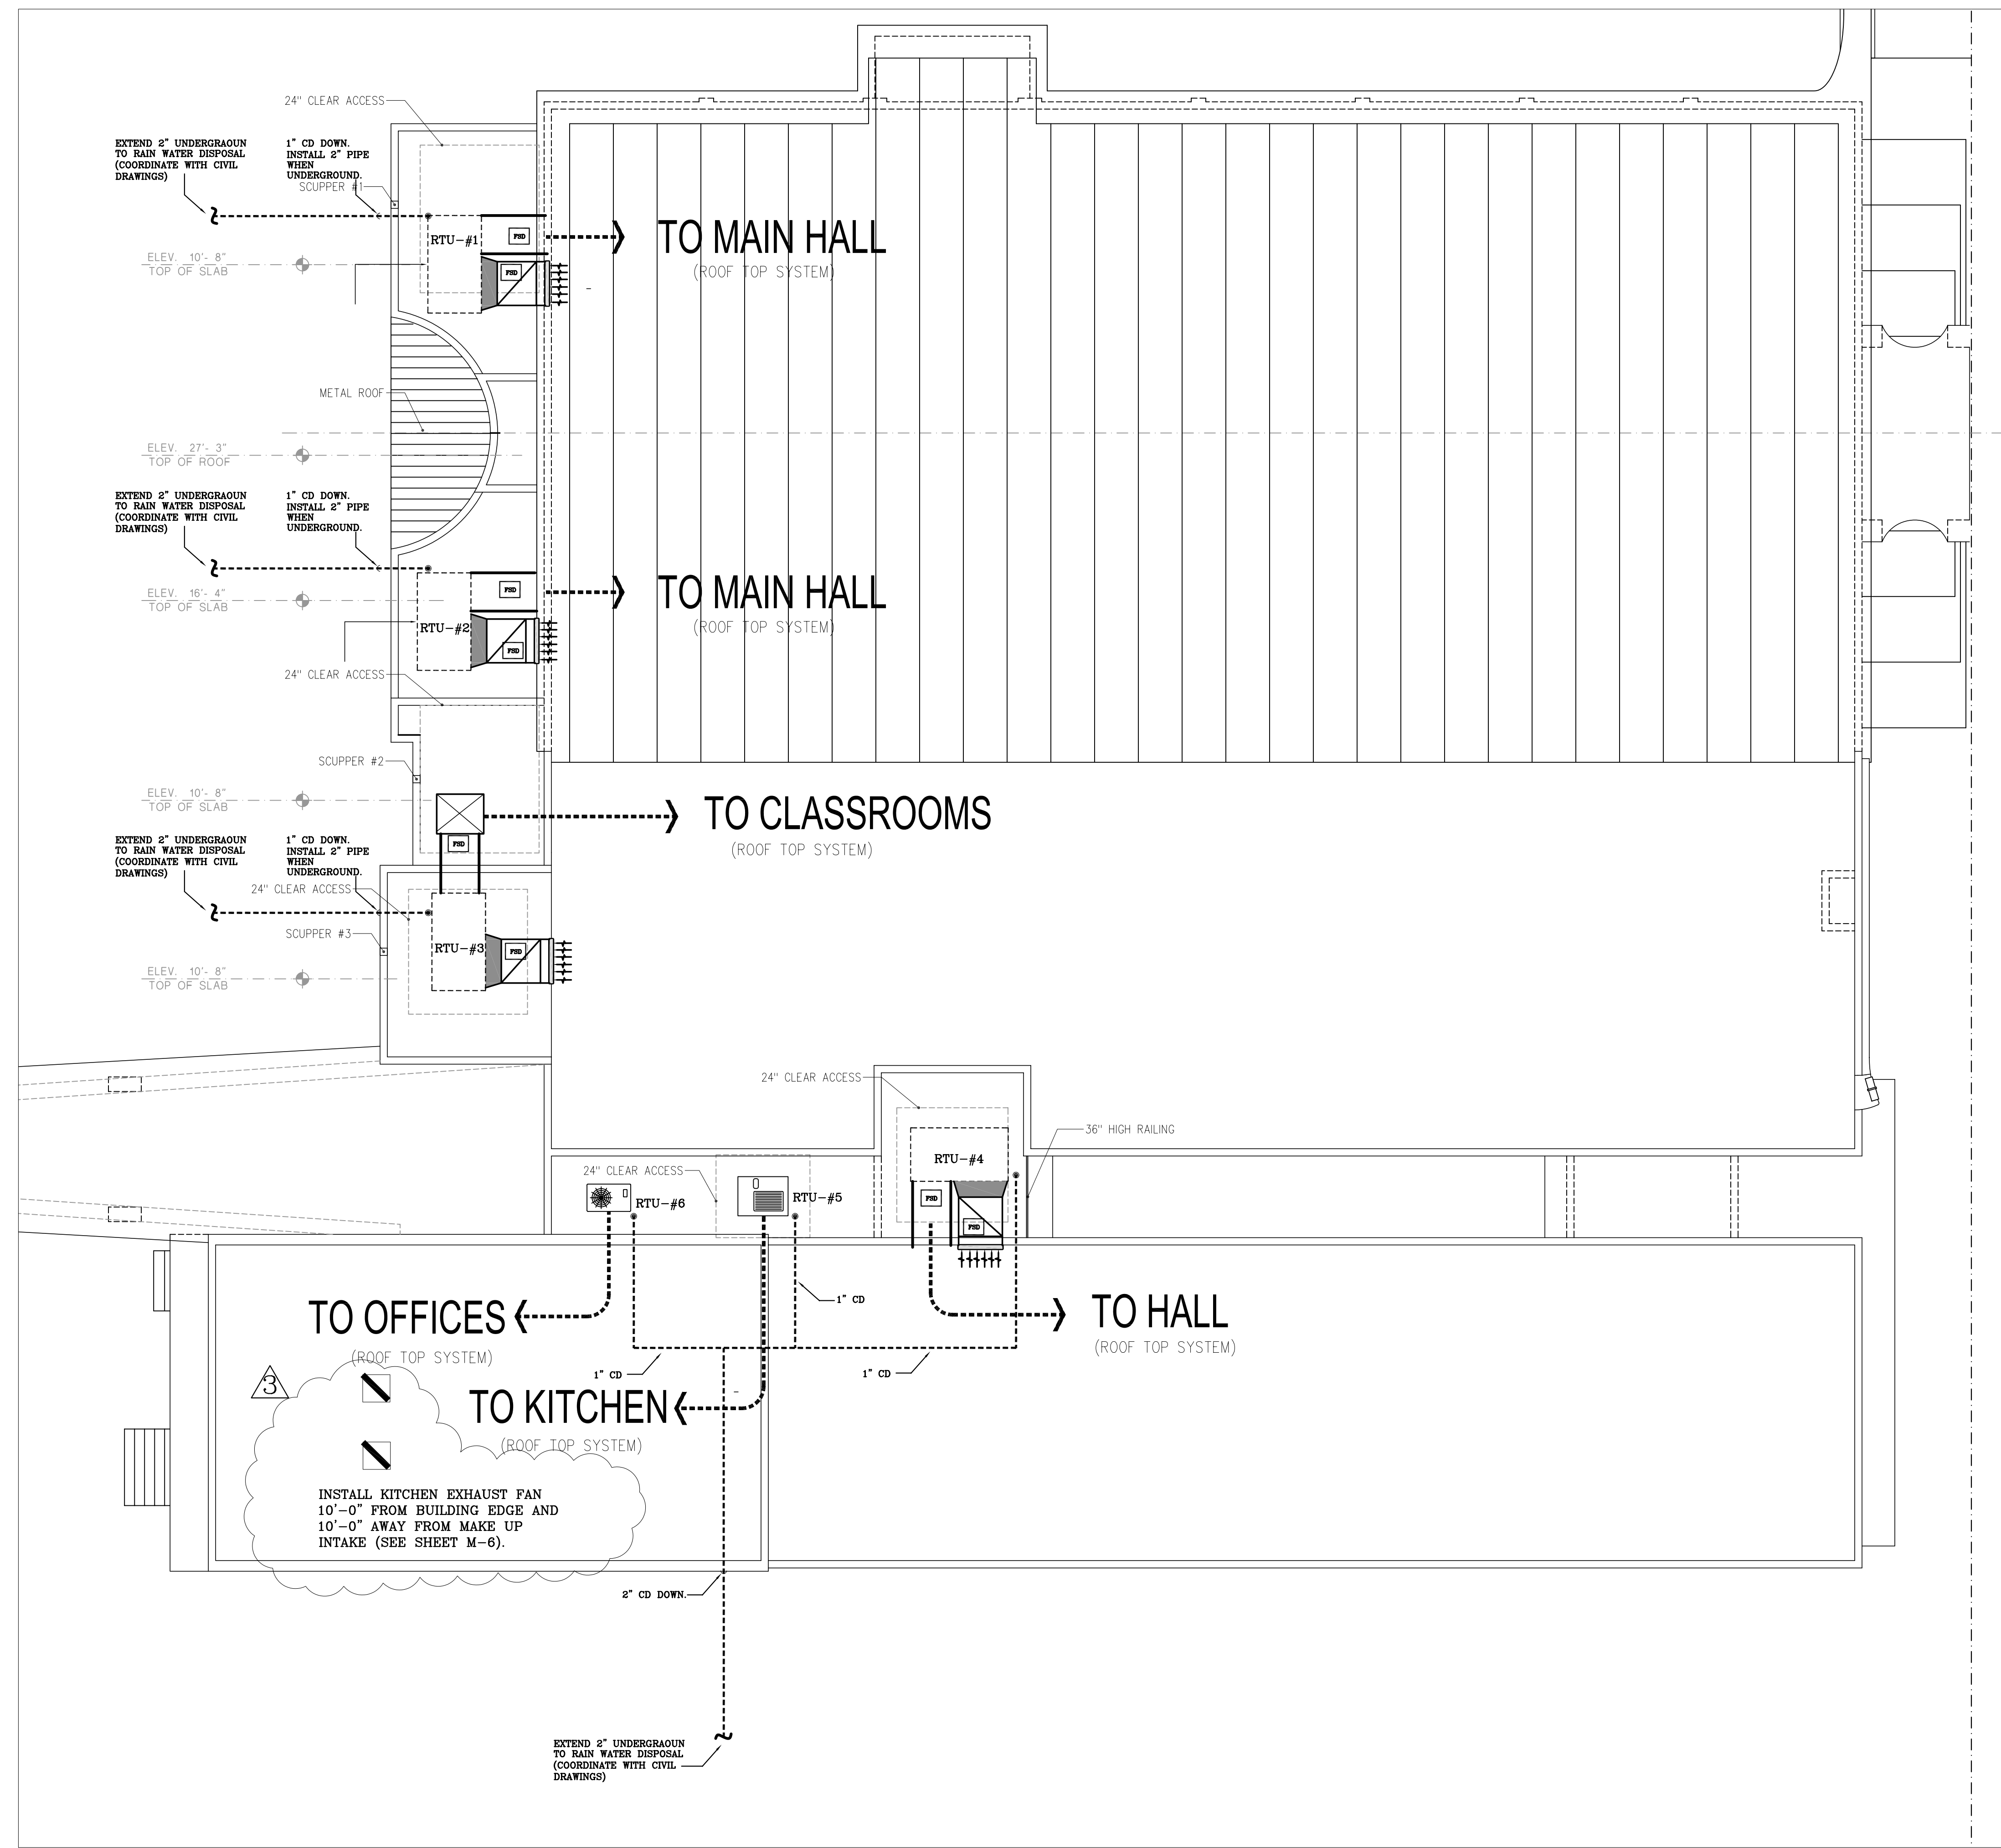

MECHANICAL ROOF PLAN
SCALE: 1/8" = 1'-0"

DANIEL F. GUTIERREZ, P.E.
LIC. #049086

7328 SW 82 ST. B-214
MIAMI FL 33143
PH: (786) 499-4167
FAX: (305) 667-5262
CELL: 786-499-4167

2
1

M-2
2 OF 6

DESIGN - INSPECTIONS

RAMOSMARTINEZ
ARCHITECTS
NEW YORK
NEWARK
JERSEY CITY, NJ 07302

954-548-5005
305-548-5029
www.rmao.com

TELEPHONE:
FACSIMILE:
WEBSITE:

MIAMI
1101 12th AVENUE
MIAMI, FL 33135

First Haitian Free Church of Nazarene by Faith

IN
ORLANDO FLORIDA

**FIRST HAITIAN
FREE CHURCH
OF NAZARENE**

308 SOUTH
ORANGE BLOSSOM TRAIL
ORLANDO, FLORIDA

REVISIONS:

1 BLDG DEPT COMM 03-26-09
3 BLDG DEPT COMM 11-09-09

COMM. NO. 08-033

DATE:

DRAWN BY:

CHECKED BY: