


SYMBOLS LEGEND

GAS RISER DIAGRAM

HVAC SPECS.

- REGISTER TYPE
- REGISTER SIZE
- CFM
- QUANTITY
- SUPPLY REGISTER W/ 6" Ø DUCT TO BRANCH
- RETURN REGISTER W/ 12" Ø DUCT TO REGISTER
- EXHAUST TO 4" Ø DUCT VENTED TO EXTERIOR
- 4" EXTERIOR EXHAUST VENT
- SUPPLY DUCT (H x W)
- RETURN DUCT (H x W)
- SMOKE DETECTION DEVICE IN DUCT
- AIR VOLUME ZONE DAMPER

NATURAL GAS METER
LOW PRESSURE GAS
METER, 5.5" IN .5" W.C.
LENGTH 100 FT MAX.

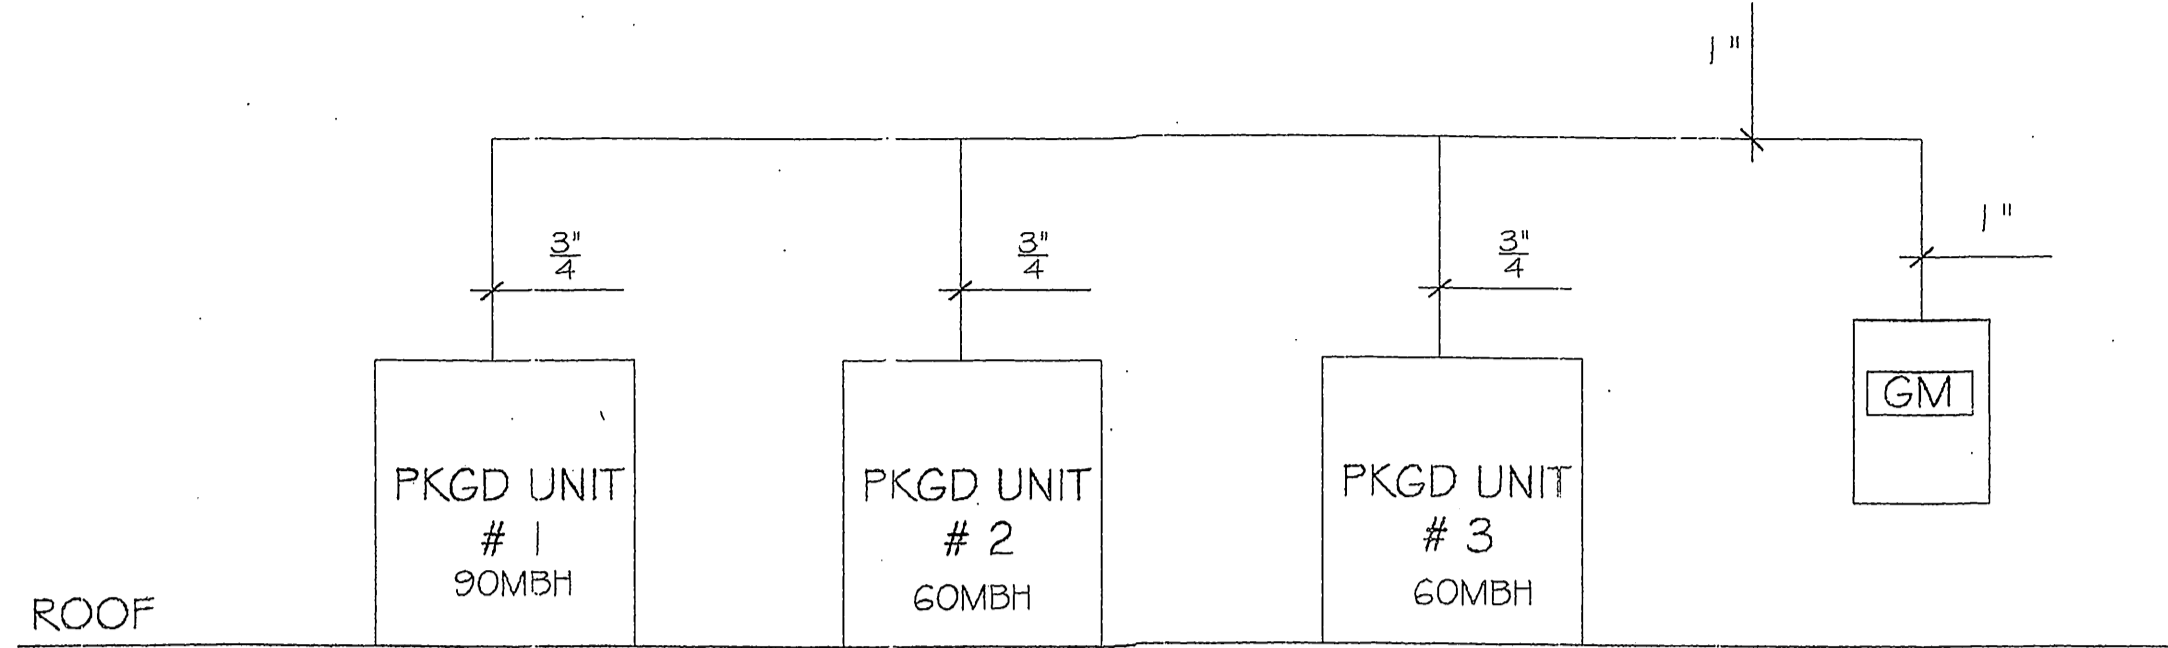

PACKAGED A/C SCHEDULE FOR TENANT SPACES

FAN	COOLING					HEATING		ELECTRIC								
	TOTAL CFM	O.A. CFM	F.S.P. (IN. W.C.)	EAT DRWS (°F)	AMB. AIR (°F)	SENS. CAP (MBTU)	TOT. CAP (MBTU)	EAT (°F)	GAS INFL (MBTU)	INDOOR FAN (HP)	COMPRESSOR (RLA)	MOCP	MCA	OUTDOOR FAN (PLA)	VOLTS PH	MANUF.
PKGD. UNITS 1-3	2000	565	0.4	81.1	67.5	98	41	56	53	90	3/4	28.9	60	43.9	2.7	208-1 Ø TRANE YCDOGO 5 TON

FIXTURE SCHEDULE

FIXTURE CONNECTION SCHEDULE


ITEM	DESCRIPTION	WASTE	VENT	CW	HW
H.S.	HAND SNK	3"	1 1/2"	1/2"	1/2"
LAV	LAVATORY	3"	1 1/2"	1/2"	1/2"
MOP SNK.	MOP SINK	3"	1 1/2"	1/2"	1/2"
WC	WATER CLOSET	3"	1 1/2"	1/2"	1/2"
URINL.	URINAL	3"	1 1/2"	1/2"	1/2"

SANITARY RISER DIAGRAM

ROOF LEVEL

SECOND LEVEL

FIRST LEVEL

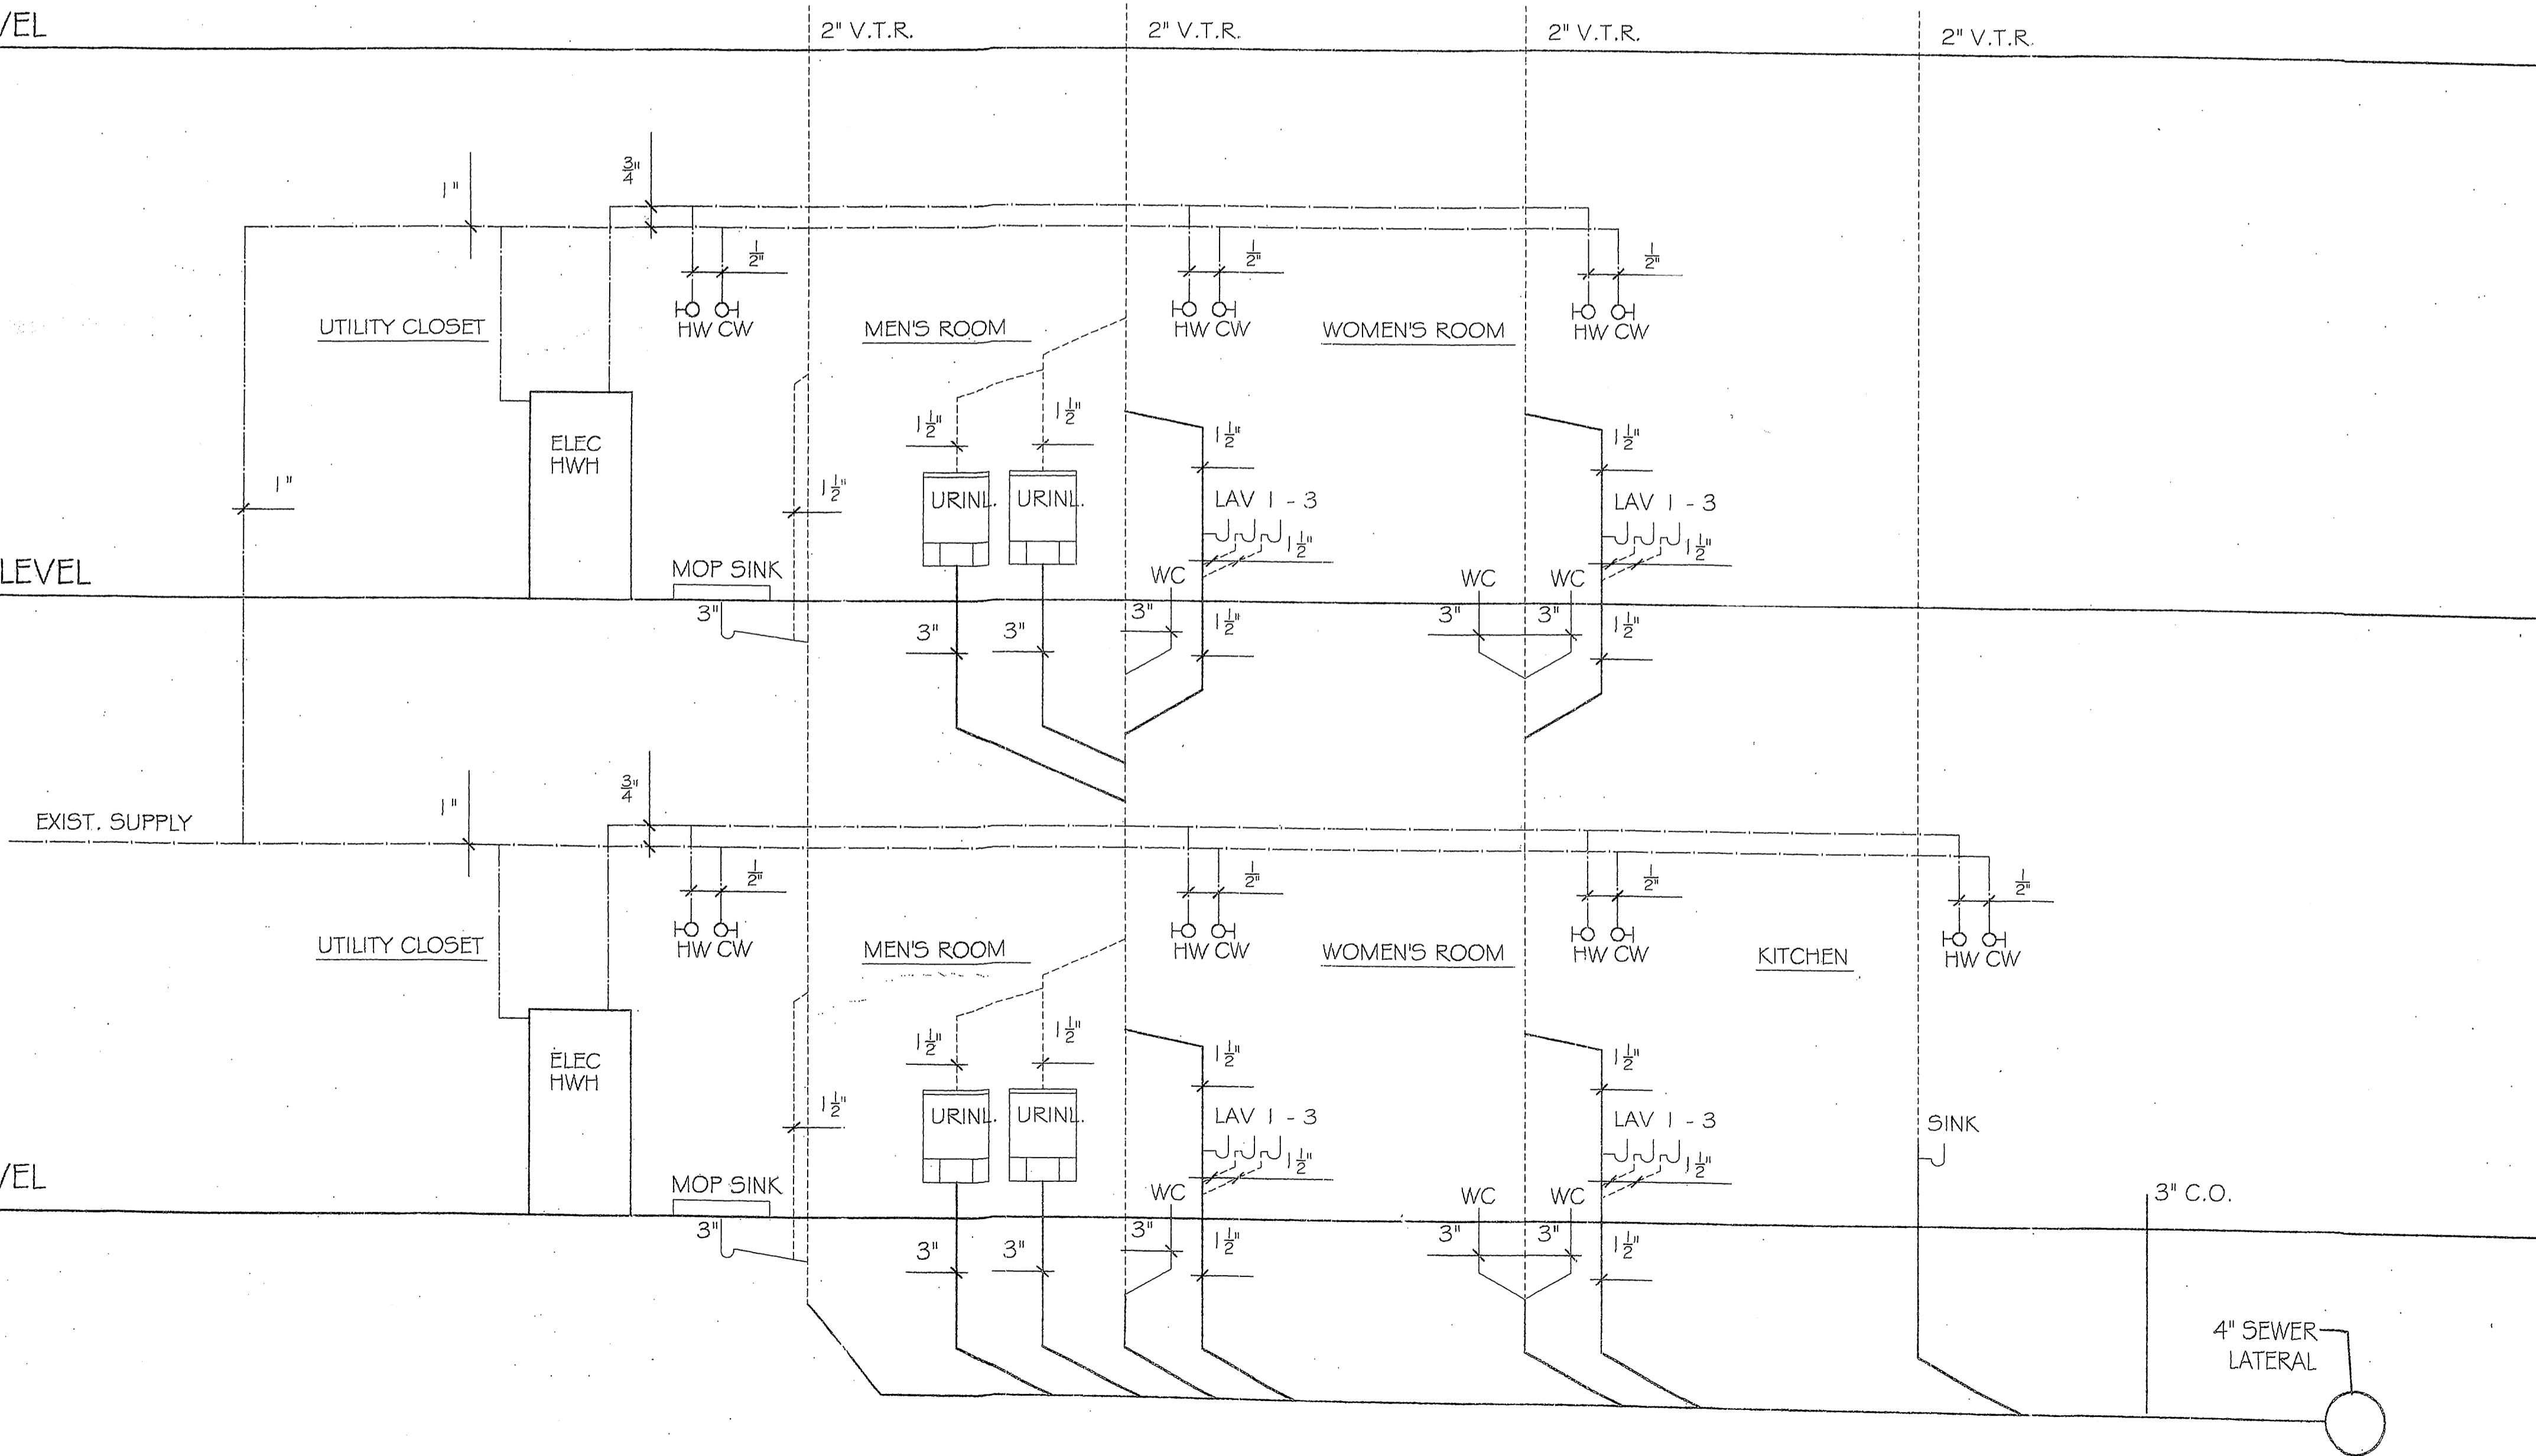

THIS DRAWING AND THE DESIGN THEREON ARE THE PROPERTY OF THE ARCHITECT AND MAY NOT BE REPRODUCED, COPIED OR USED WITHOUT WRITTEN PERMISSION.
 COPYRIGHT ©2006

SCHEMATIC DESIGN

REVISIONS

DATE:	08-20-06
DRAWN BY:	G.R.N.
JOB NO:	00-00-01

M.I.