




LEGEND	
WMH	WATER HEATER
HM	HOT WATER
CM	COLD WATER
SS	SANITARY SLAB
V	VENT
6	6" GAS REGULATOR VALVE
6	6" GAS METER
6	6" WATER METER
6	CLEAN OUT
6	WALL CLEAN OUT
6	VENT THRU ROOF
6	TRAP SEAL PRIMER
6	BACKFLOW PREVENTER
6	SHUT OFF VALVE

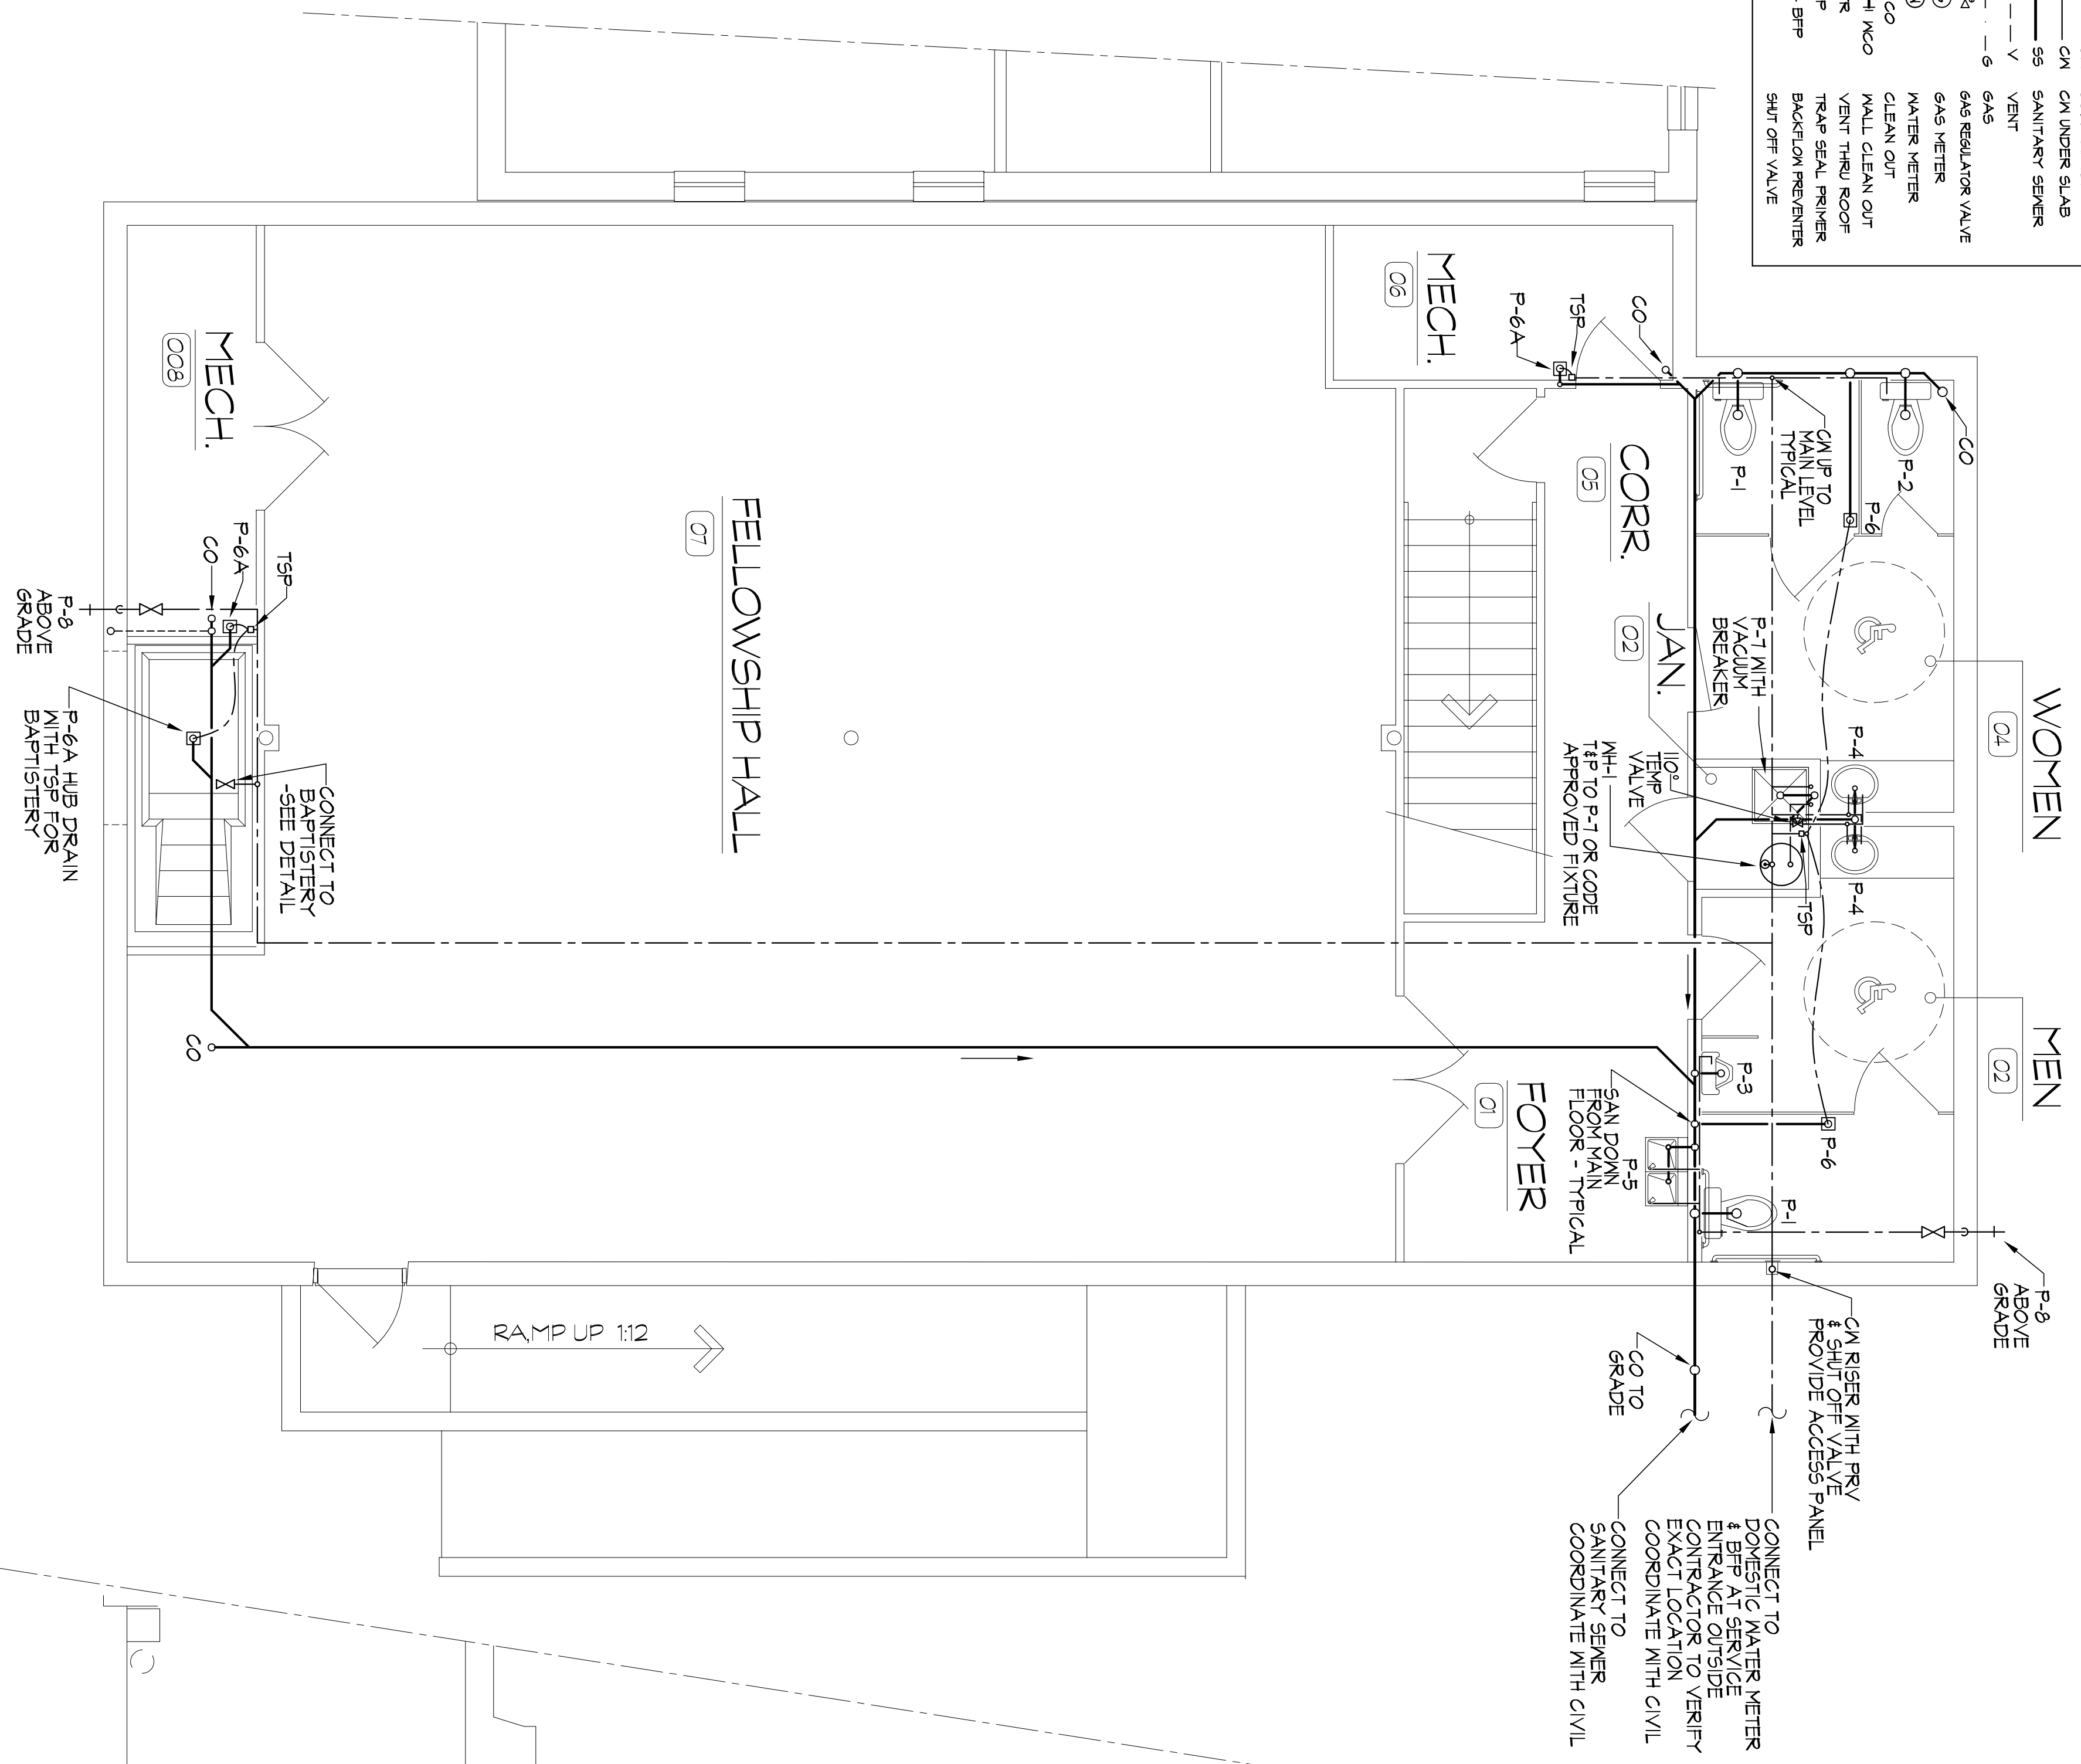

1
SCALE: 1/4" = 1'-0"
2,459 S.F.
basement floor plan

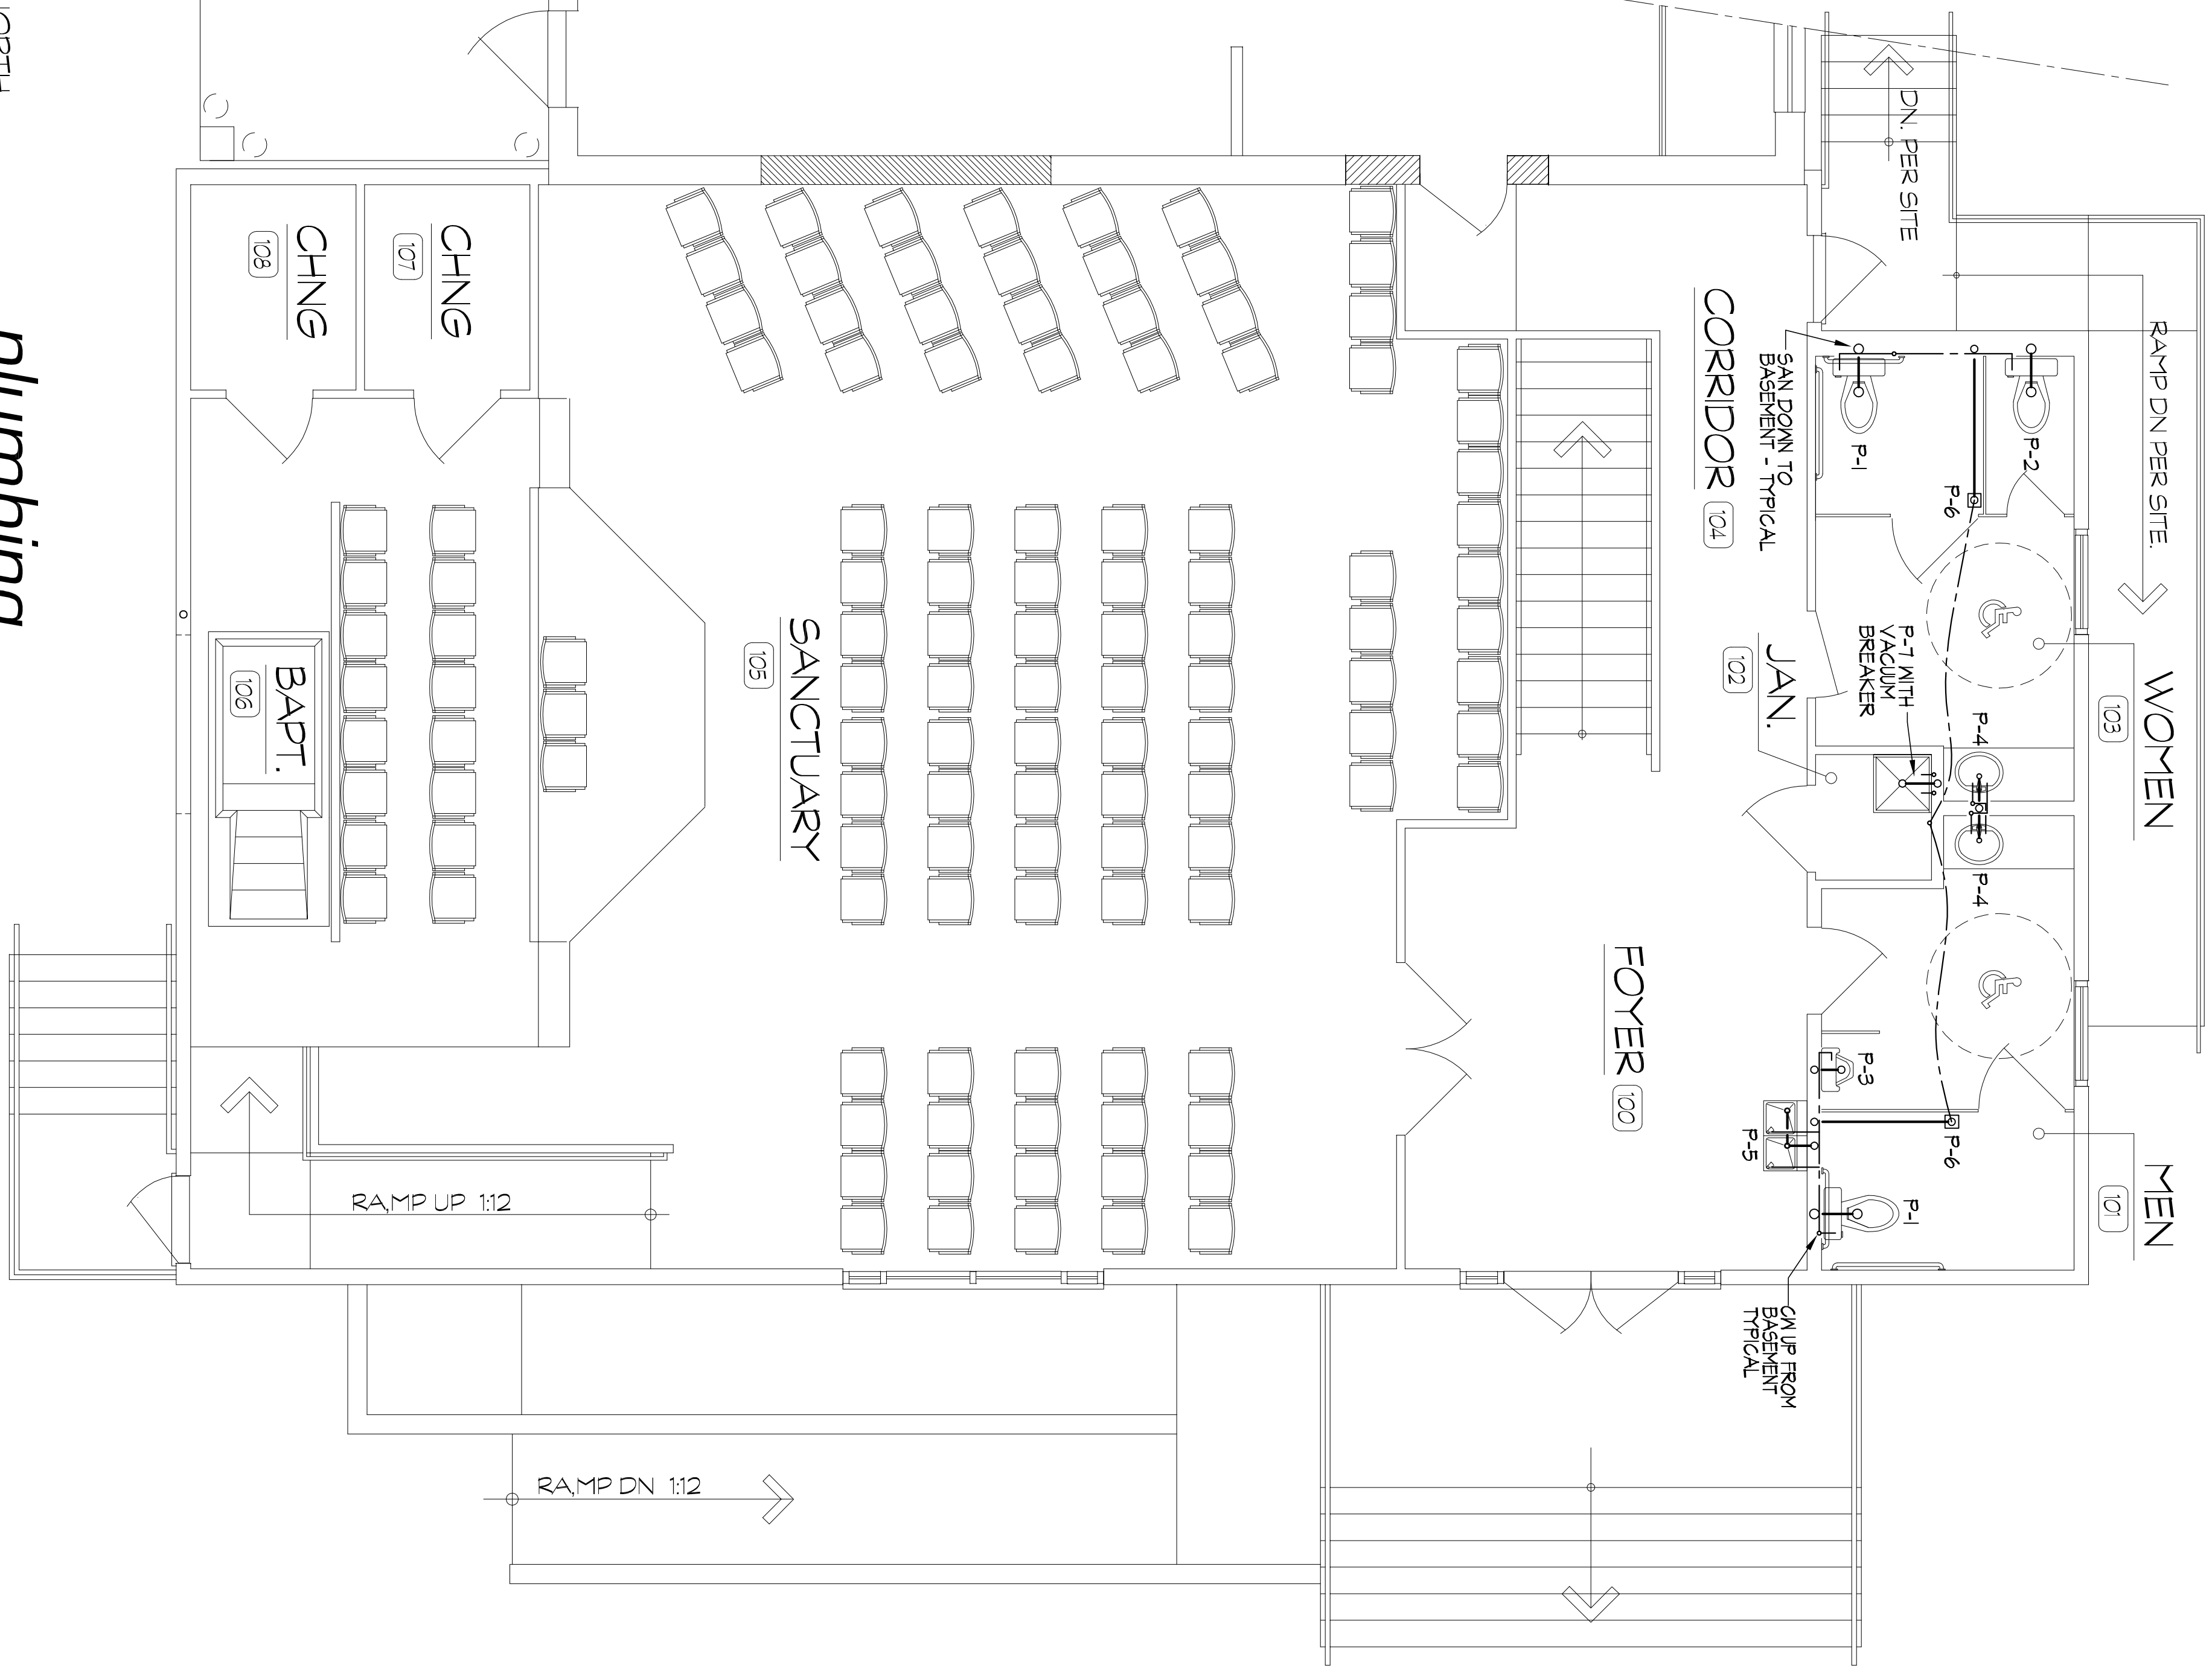

2
SCALE: 1/4" = 1'-0"
2,459 S.F.
plumbing main floor plan

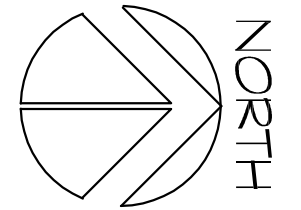

NO.	REVISIONS
1	REVISED
2	REVISED
3	REVISED
4	REVISED
5	REVISED

rick jack/design
 25 HEMLOCK RIDGE ROAD
 LEICESTER, NORTH CAROLINA 28748
 PH: 828-683-7348 FAX: 828-683-9902
 email: rick@rickjackdesign.com

new facility for:
washington seventh day baptist church
 CRITTENDEN @ 16TH, WASHINGTON, D.C.

project no.	2K70609
drawn by:	RP1
date:	AUG. 18, 2008
scale:	AS SHOWN
sheet no.:	P1