


LEGEND	
NH-1	WATER HEATER
HM	HOT WATER
CM	COLD WATER
SS	SANITARY SEWER
V	VENT
6	GAS
6	GAS REGULATOR VALVE
6	GAS METER
6	MATER METER
6	CLEAN OUT
6	WALL CLEAN OUT
6	VENT THRU ROOF
6	TRAP SEAL PRIMER
6	BACKFLOW PREVENTER
6	SHUT OFF VALVE

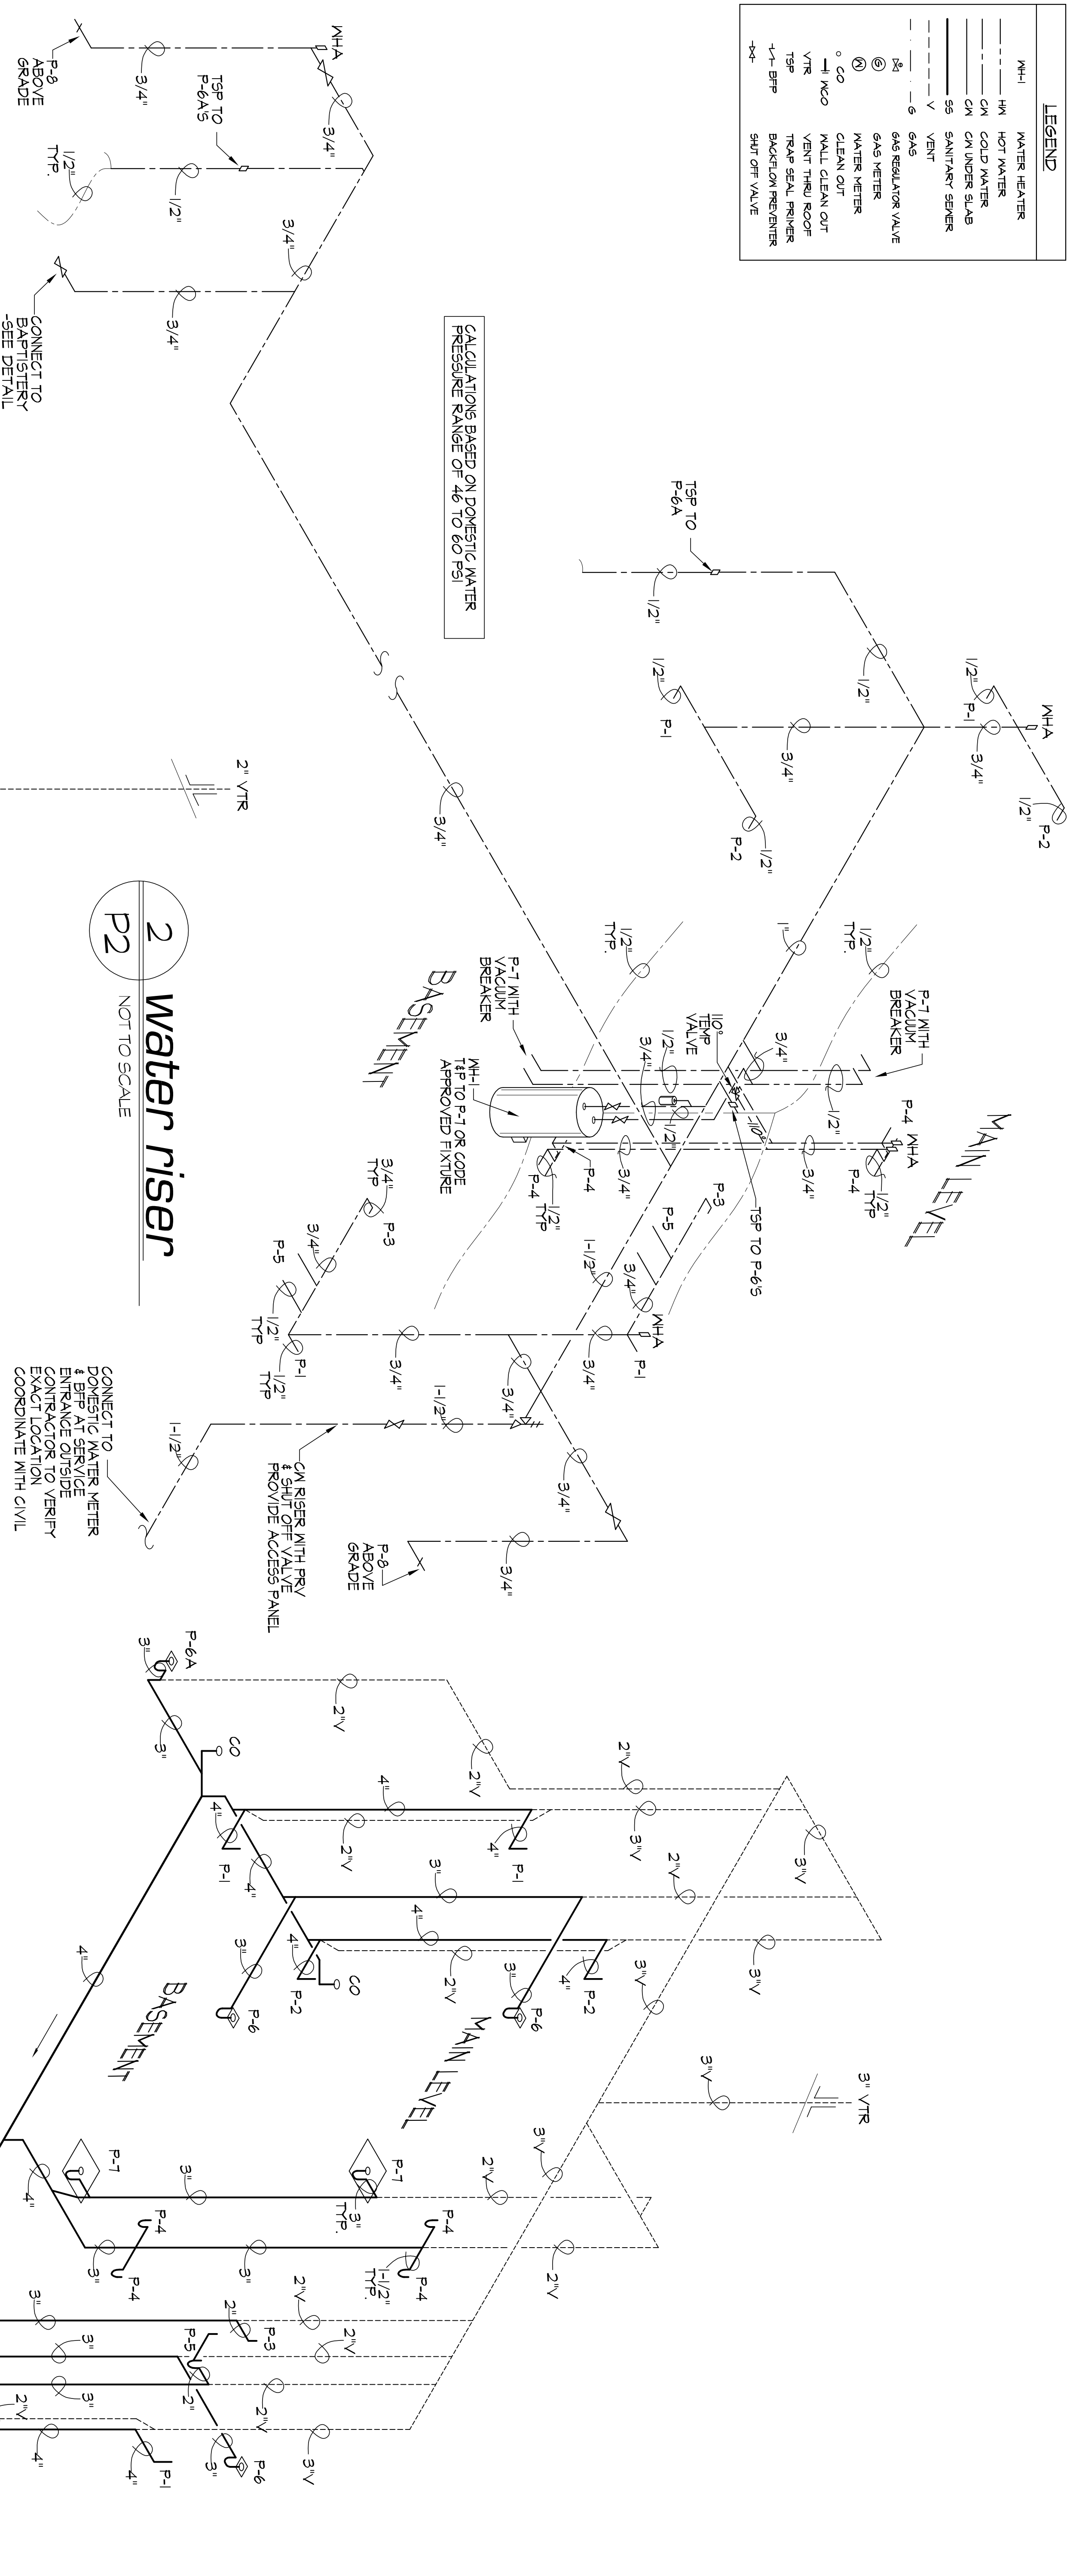


TOTAL FIXTURE UNITS - WATER DEMAND & DRAINAGE

FIXTURES	NUMBER (#) OF FIXTURES	CM SUPPLY		DRAINAGE	
		SUPPLY UNIT	TOTAL NUMBER (#) OF SUPPLY FIXTURE UNITS	DRAINAGE UNIT	TOTAL NUMBER (#) OF DRAINAGE FIXTURE UNITS
LAVATORY	4	2	8	2	8
DRINKING FOUNTAIN	4	2	8	1	4
URINAL	2	4	8	2	4
WATER CLOSET (TANK)	6	5	30	6	36
FLUSH DRAINS	7	---	---	6	42
MOP SINK	2	4	8	6	12
BAPTISTRY	1	4	4	---	---
HOSE BIBBS	2	5	10	---	---
TOTAL			76	TOTAL	106

2 water riser
NOT TO SCALE

1 sanitary riser
NOT TO SCALE

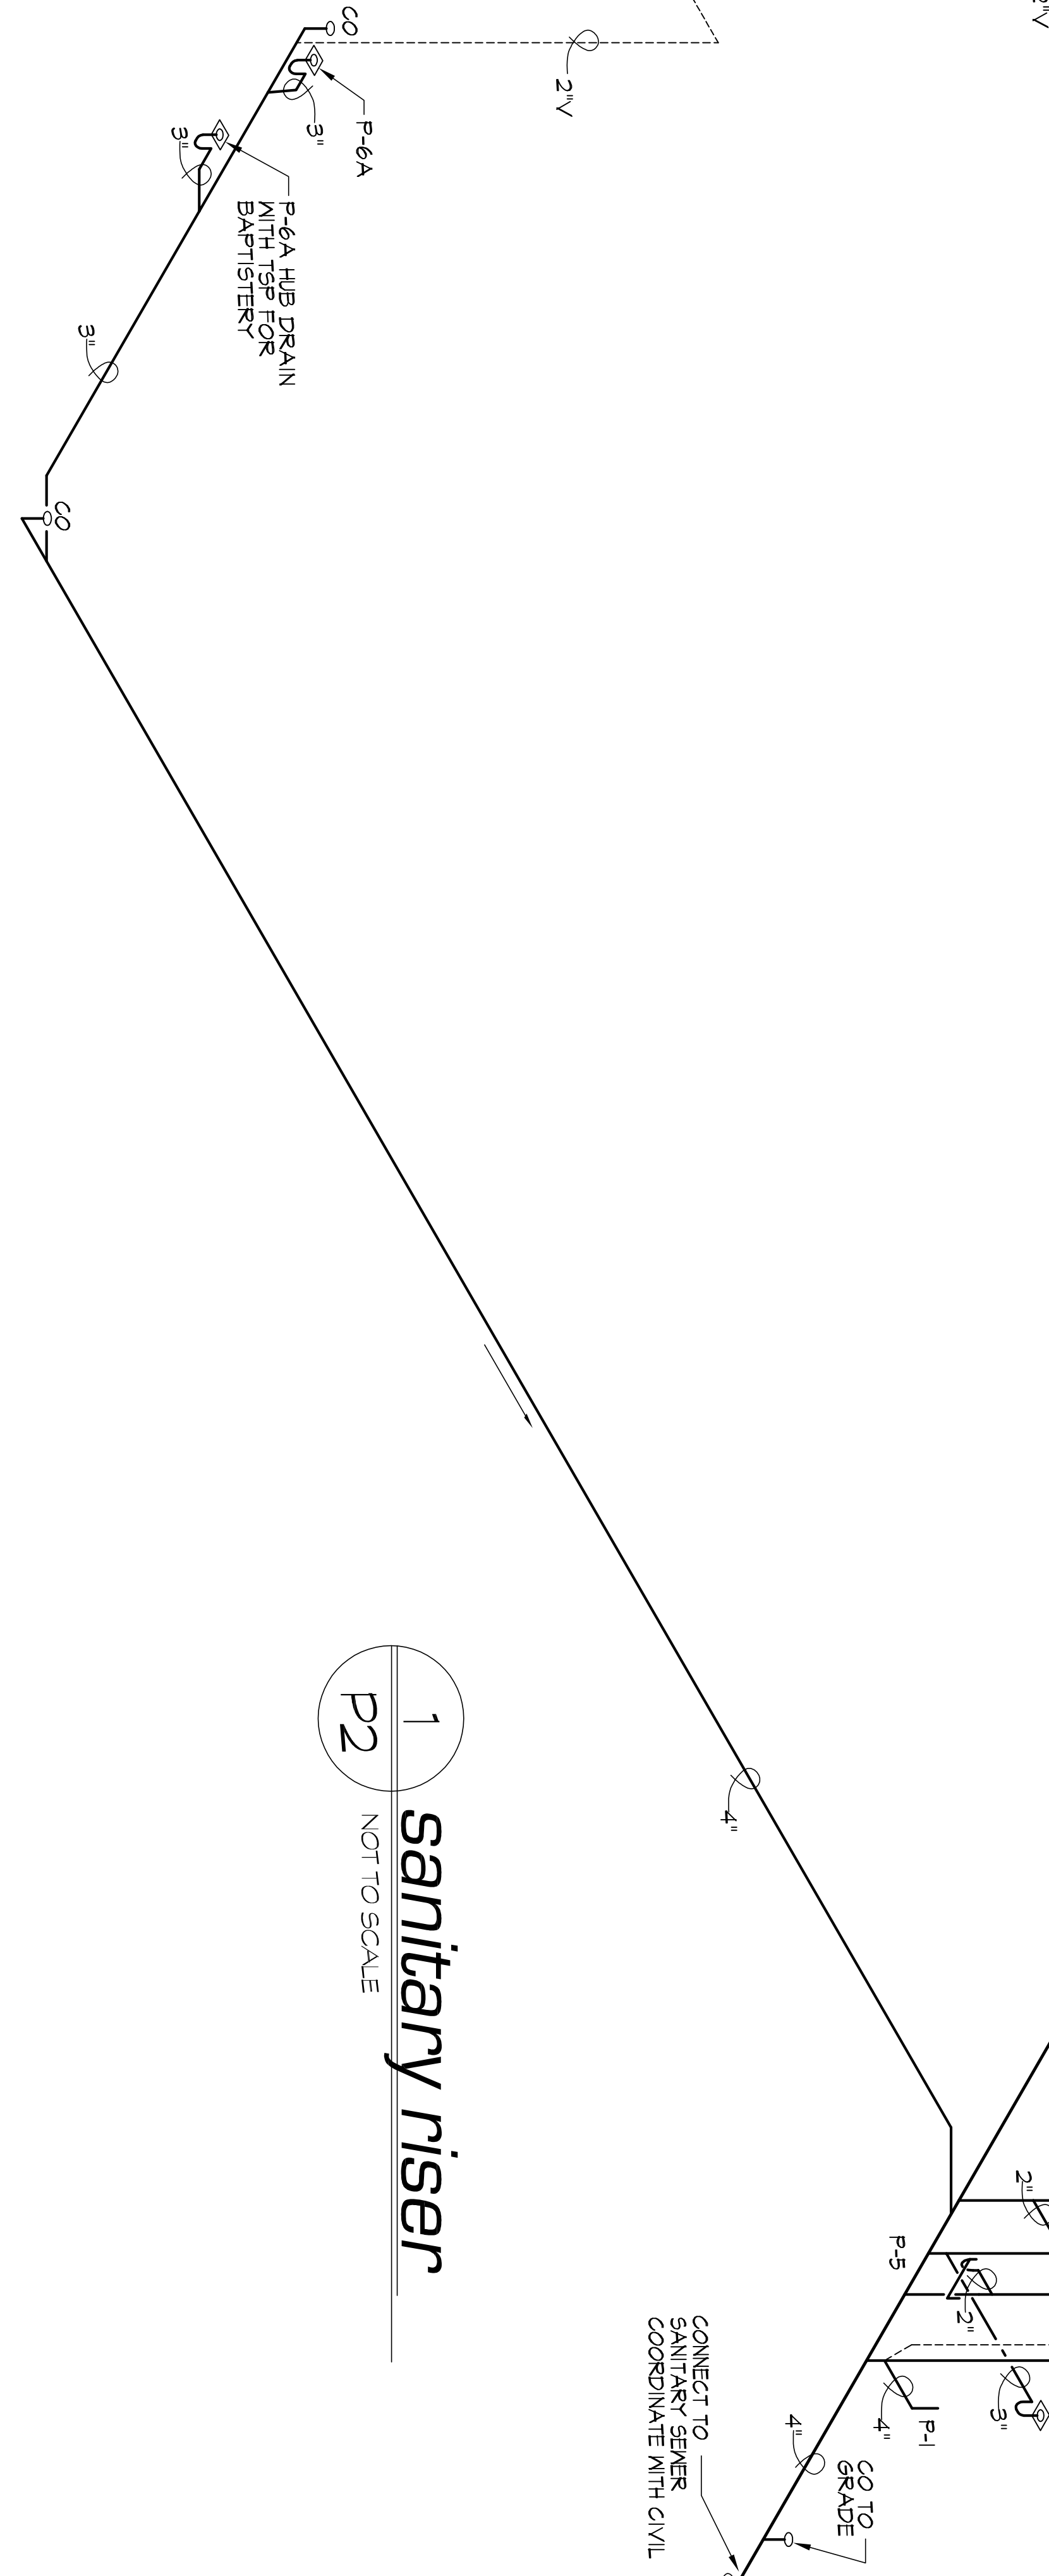

project no. 2K70609
 drawn by: RPI
 date: AUG. 18, 2008
 scale: AS SHOWN
 sheet no. **P2**

new facility for:
washington seventh day baptist church
 CRITTENDEN @ 16TH, WASHINGTON, D.C.

REVISIONS

1	
2	
3	
4	
5	

THESE AND/OR REVISIONS ARE THE PROPERTY OF THE DESIGNER AND THE CLIENT. ANY REVISIONS TO THE ORIGINAL DRAWING MUST BE APPROVED BY THE DESIGNER AND THE CLIENT.

rick jack/design
 25 HEMLOCK RIDGE ROAD
 LEICESTER, NORTH CAROLINA 28748
 PH: 828-683-7348 FAX: 828-683-9902
 email: rick@rickjackdesign.com